

Camila Carmen Interiors

FULL WORKS

DESIGN CRED: SOHO HOME



CLIENT:

XXXXXX

PROJECT NAME:

BAKEWELL BEDROOM

DATE:

JULY 2023

*Great design is not just
about how it looks, but how
it makes you feel...*

CONTENTS

03. OVERVIEW
An overview of the project key elements.

04. FLOOR PLAN
An overview of the overall floor plan.

05. MOOD BOARD
Inspiration for colours, material, shapes.

06. JOINERY MOOD BOARD
Inspiration for colours, material, shapes.

07. FURNITURE SELECTION
Furniture selection by room.

08. COLOURS
Overview of all colours by room.

09. MATERIALS
Overview of materials throughout.

10. ELEVATIONS
2D drawings illustrating the layout and dimensions.

11. BESPOKE JOINERY
Technical details of bespoke joinery.

12. CUSTOM CURTAINS
Material details of a custom piece.

13. LIGHTING PLAN
A detailed plan of lighting.

14. RESULTS
Photos of the before and after.

OVERVIEW

Camila Carmen Interiors

CONCEPT MOOD BOARD COLOR PALETTE MATERIALS FLOOR PLAN FURNITURES

DESIGN CRED: JAKE ARNOLD




MID CENTURY CHARM

The project prioritises simplicity, functionality, and a welcoming atmosphere. The design incorporates soft textures and fabrics, featured not only in the joinery but also in the light shades, relaxed romans, and bed layers. This approach creates a cozy and inviting ambiance.

Furnishings are selected for their practical and comfortable design, emphasizing both style and utility.

MATERIALS:


Incorporating materials like rich dark woods and tactile linens brings warmth and texture to the space, while touches of black or deeper shades create contrast and depth against lighter sandy tones.

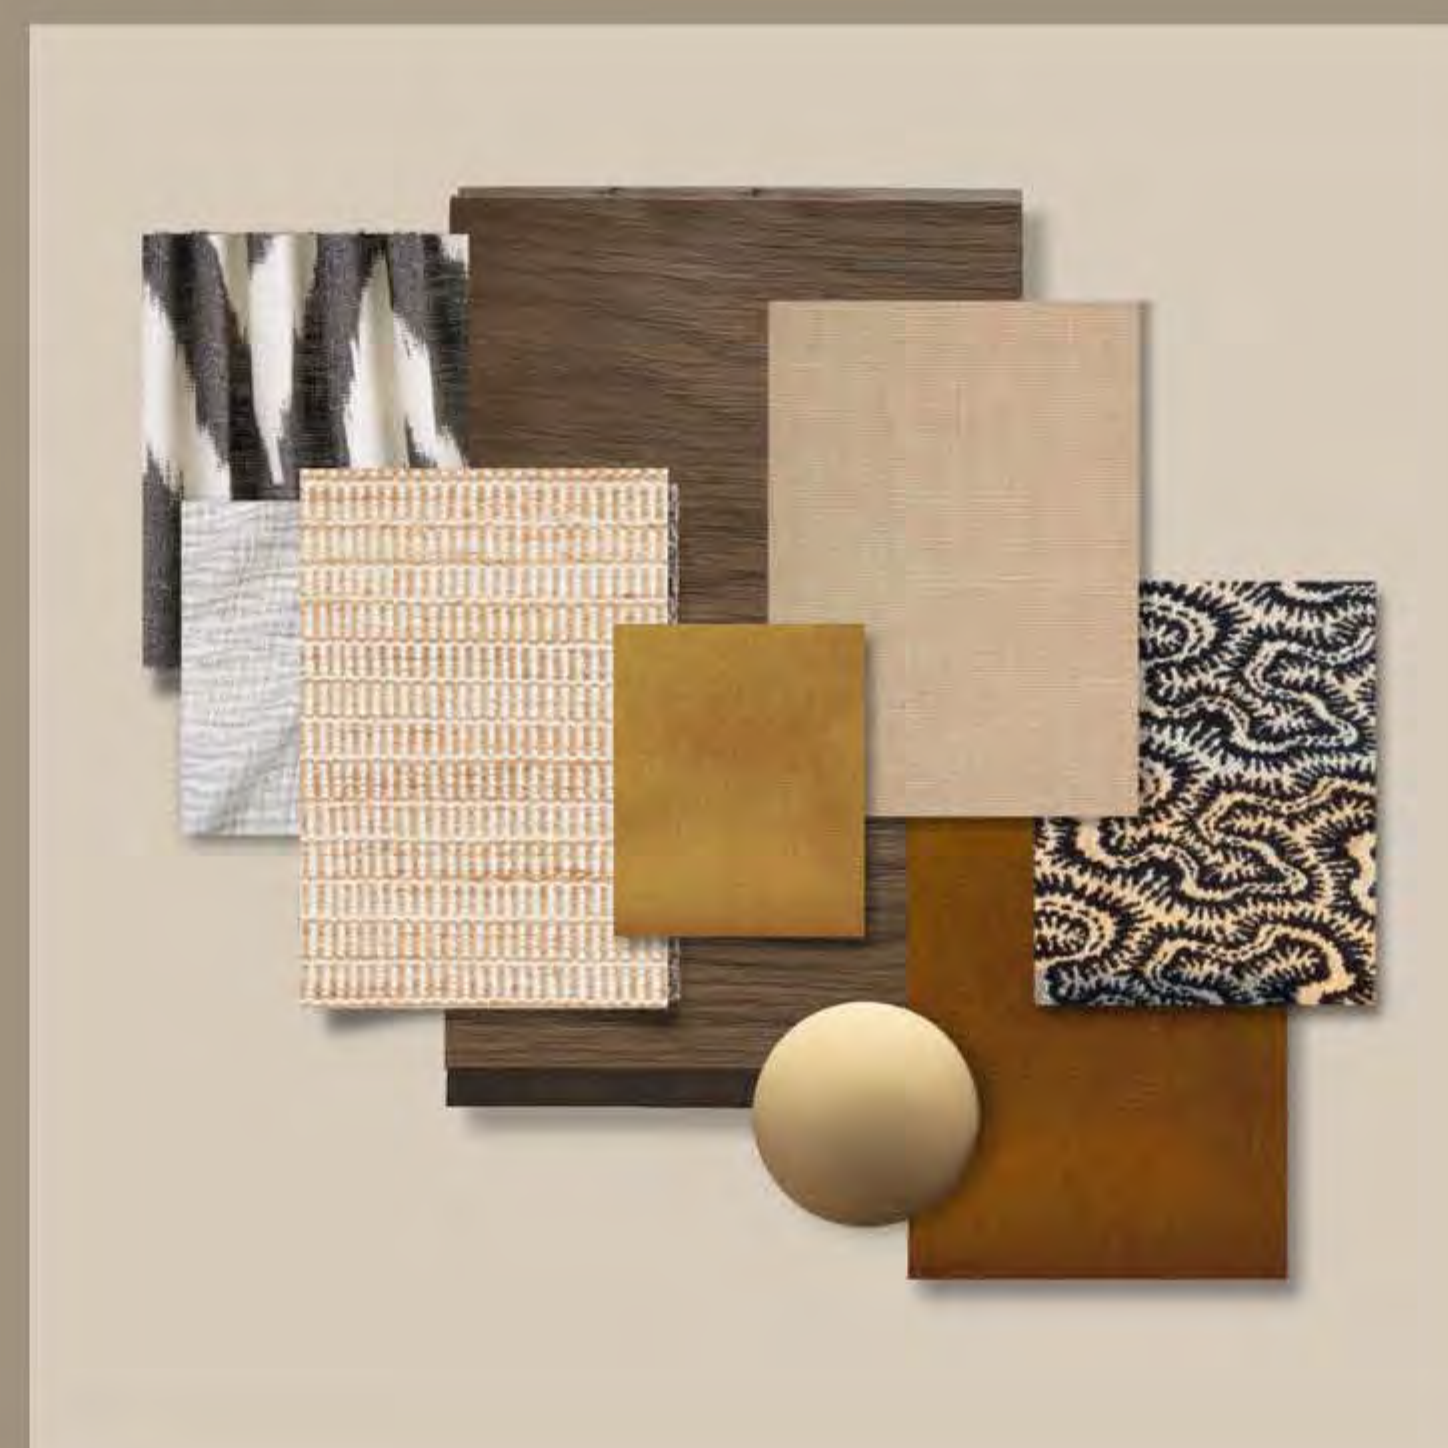

COLOUR PALETTE




FLOOR PLAN

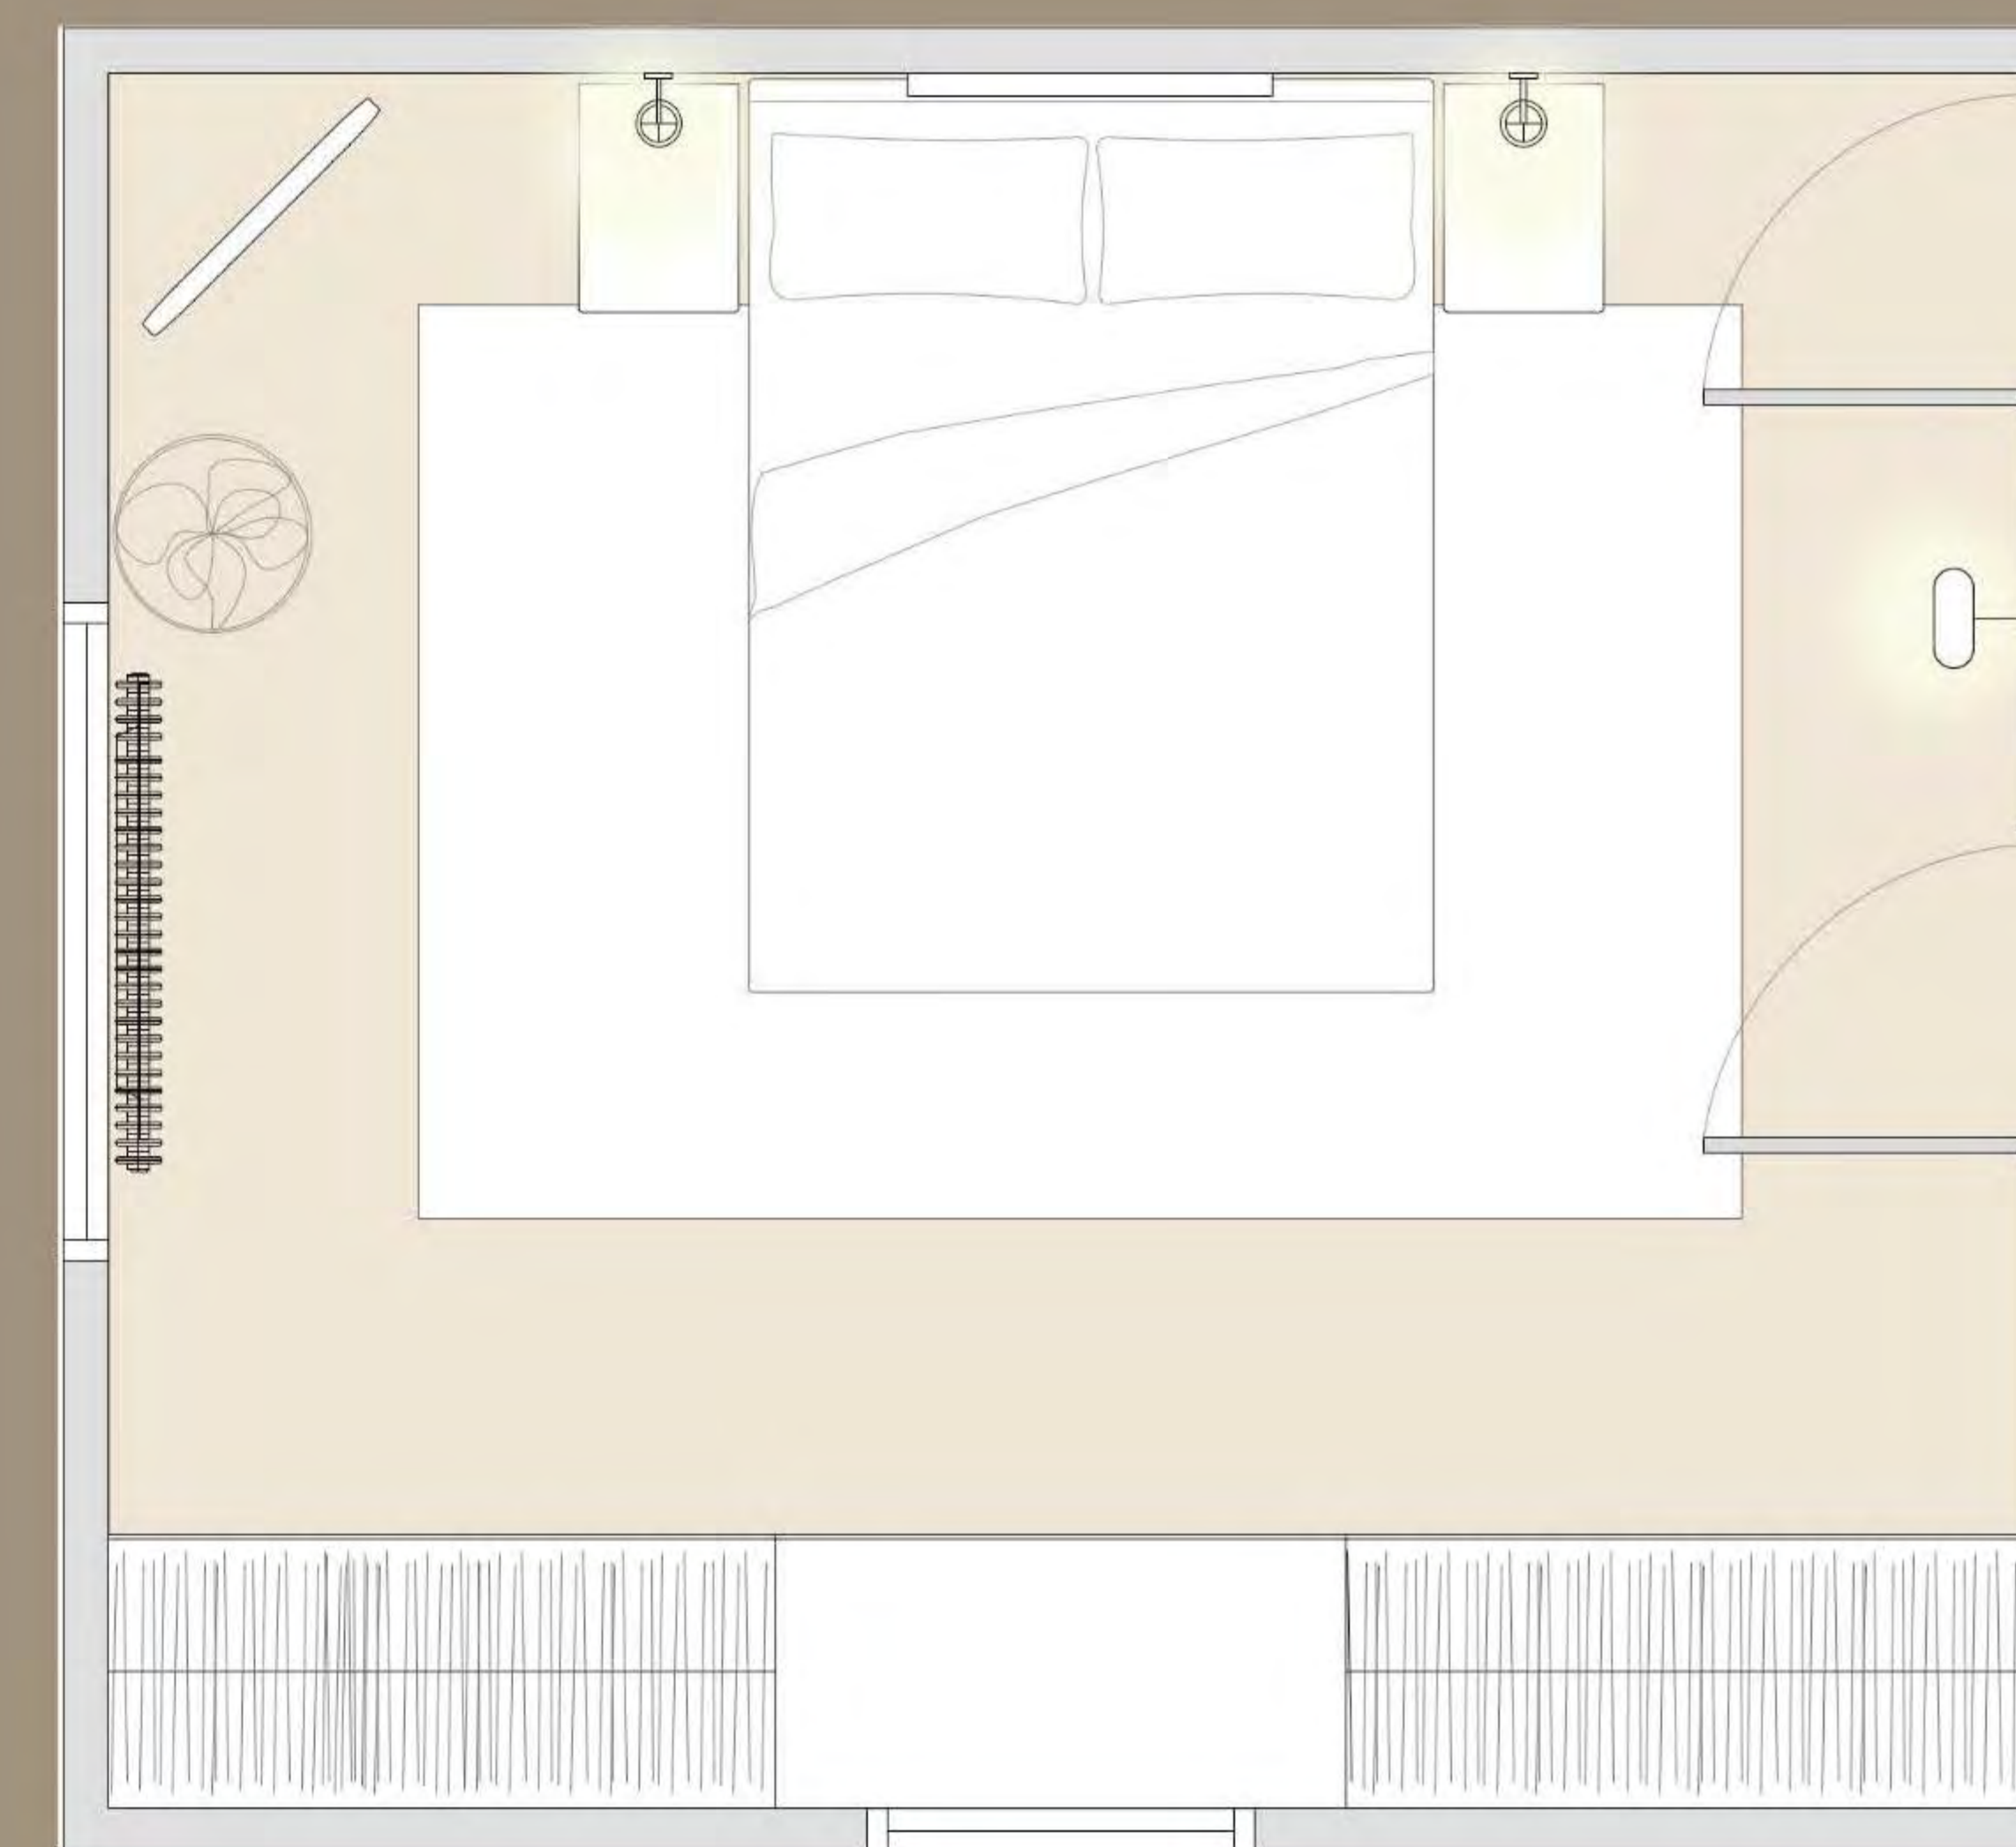

FLOOR

PRIMARY BEDROOM

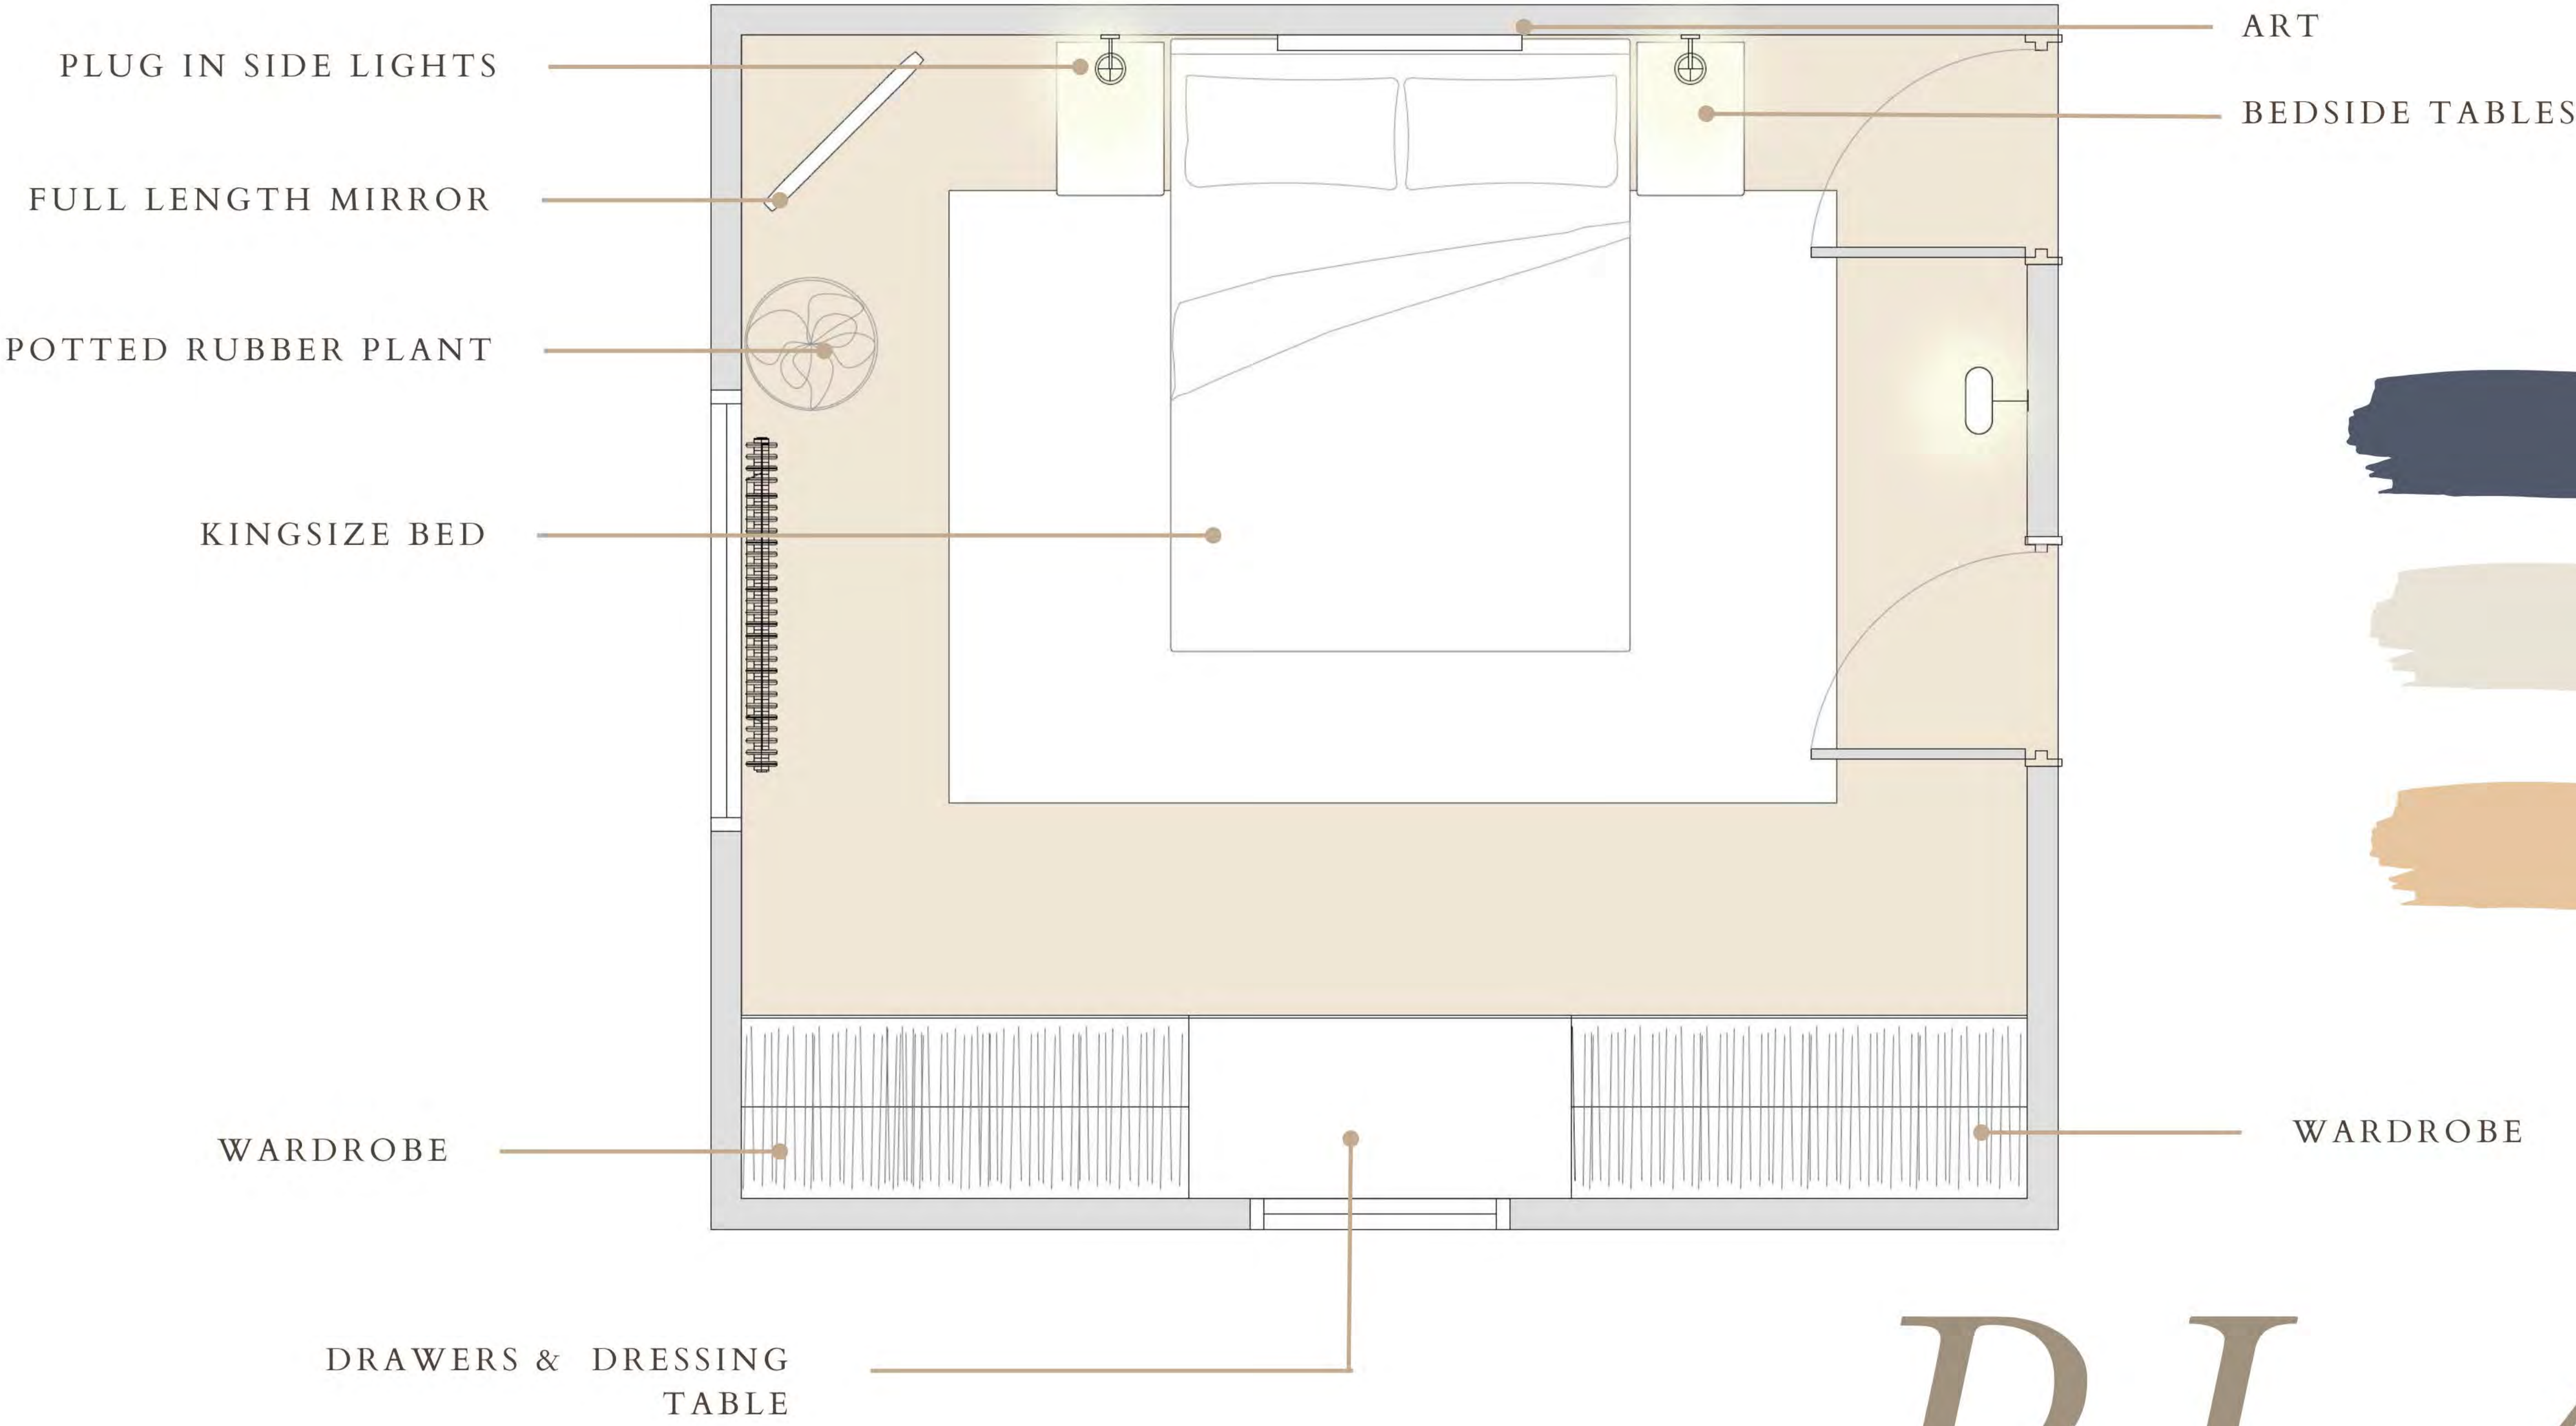

PLAN


PHOTO CRED: SOHO HOME



PHOTO CRED: HEIDI CAILLIER DESIGN:



PHOTO CRED: IISE CRAWFORD

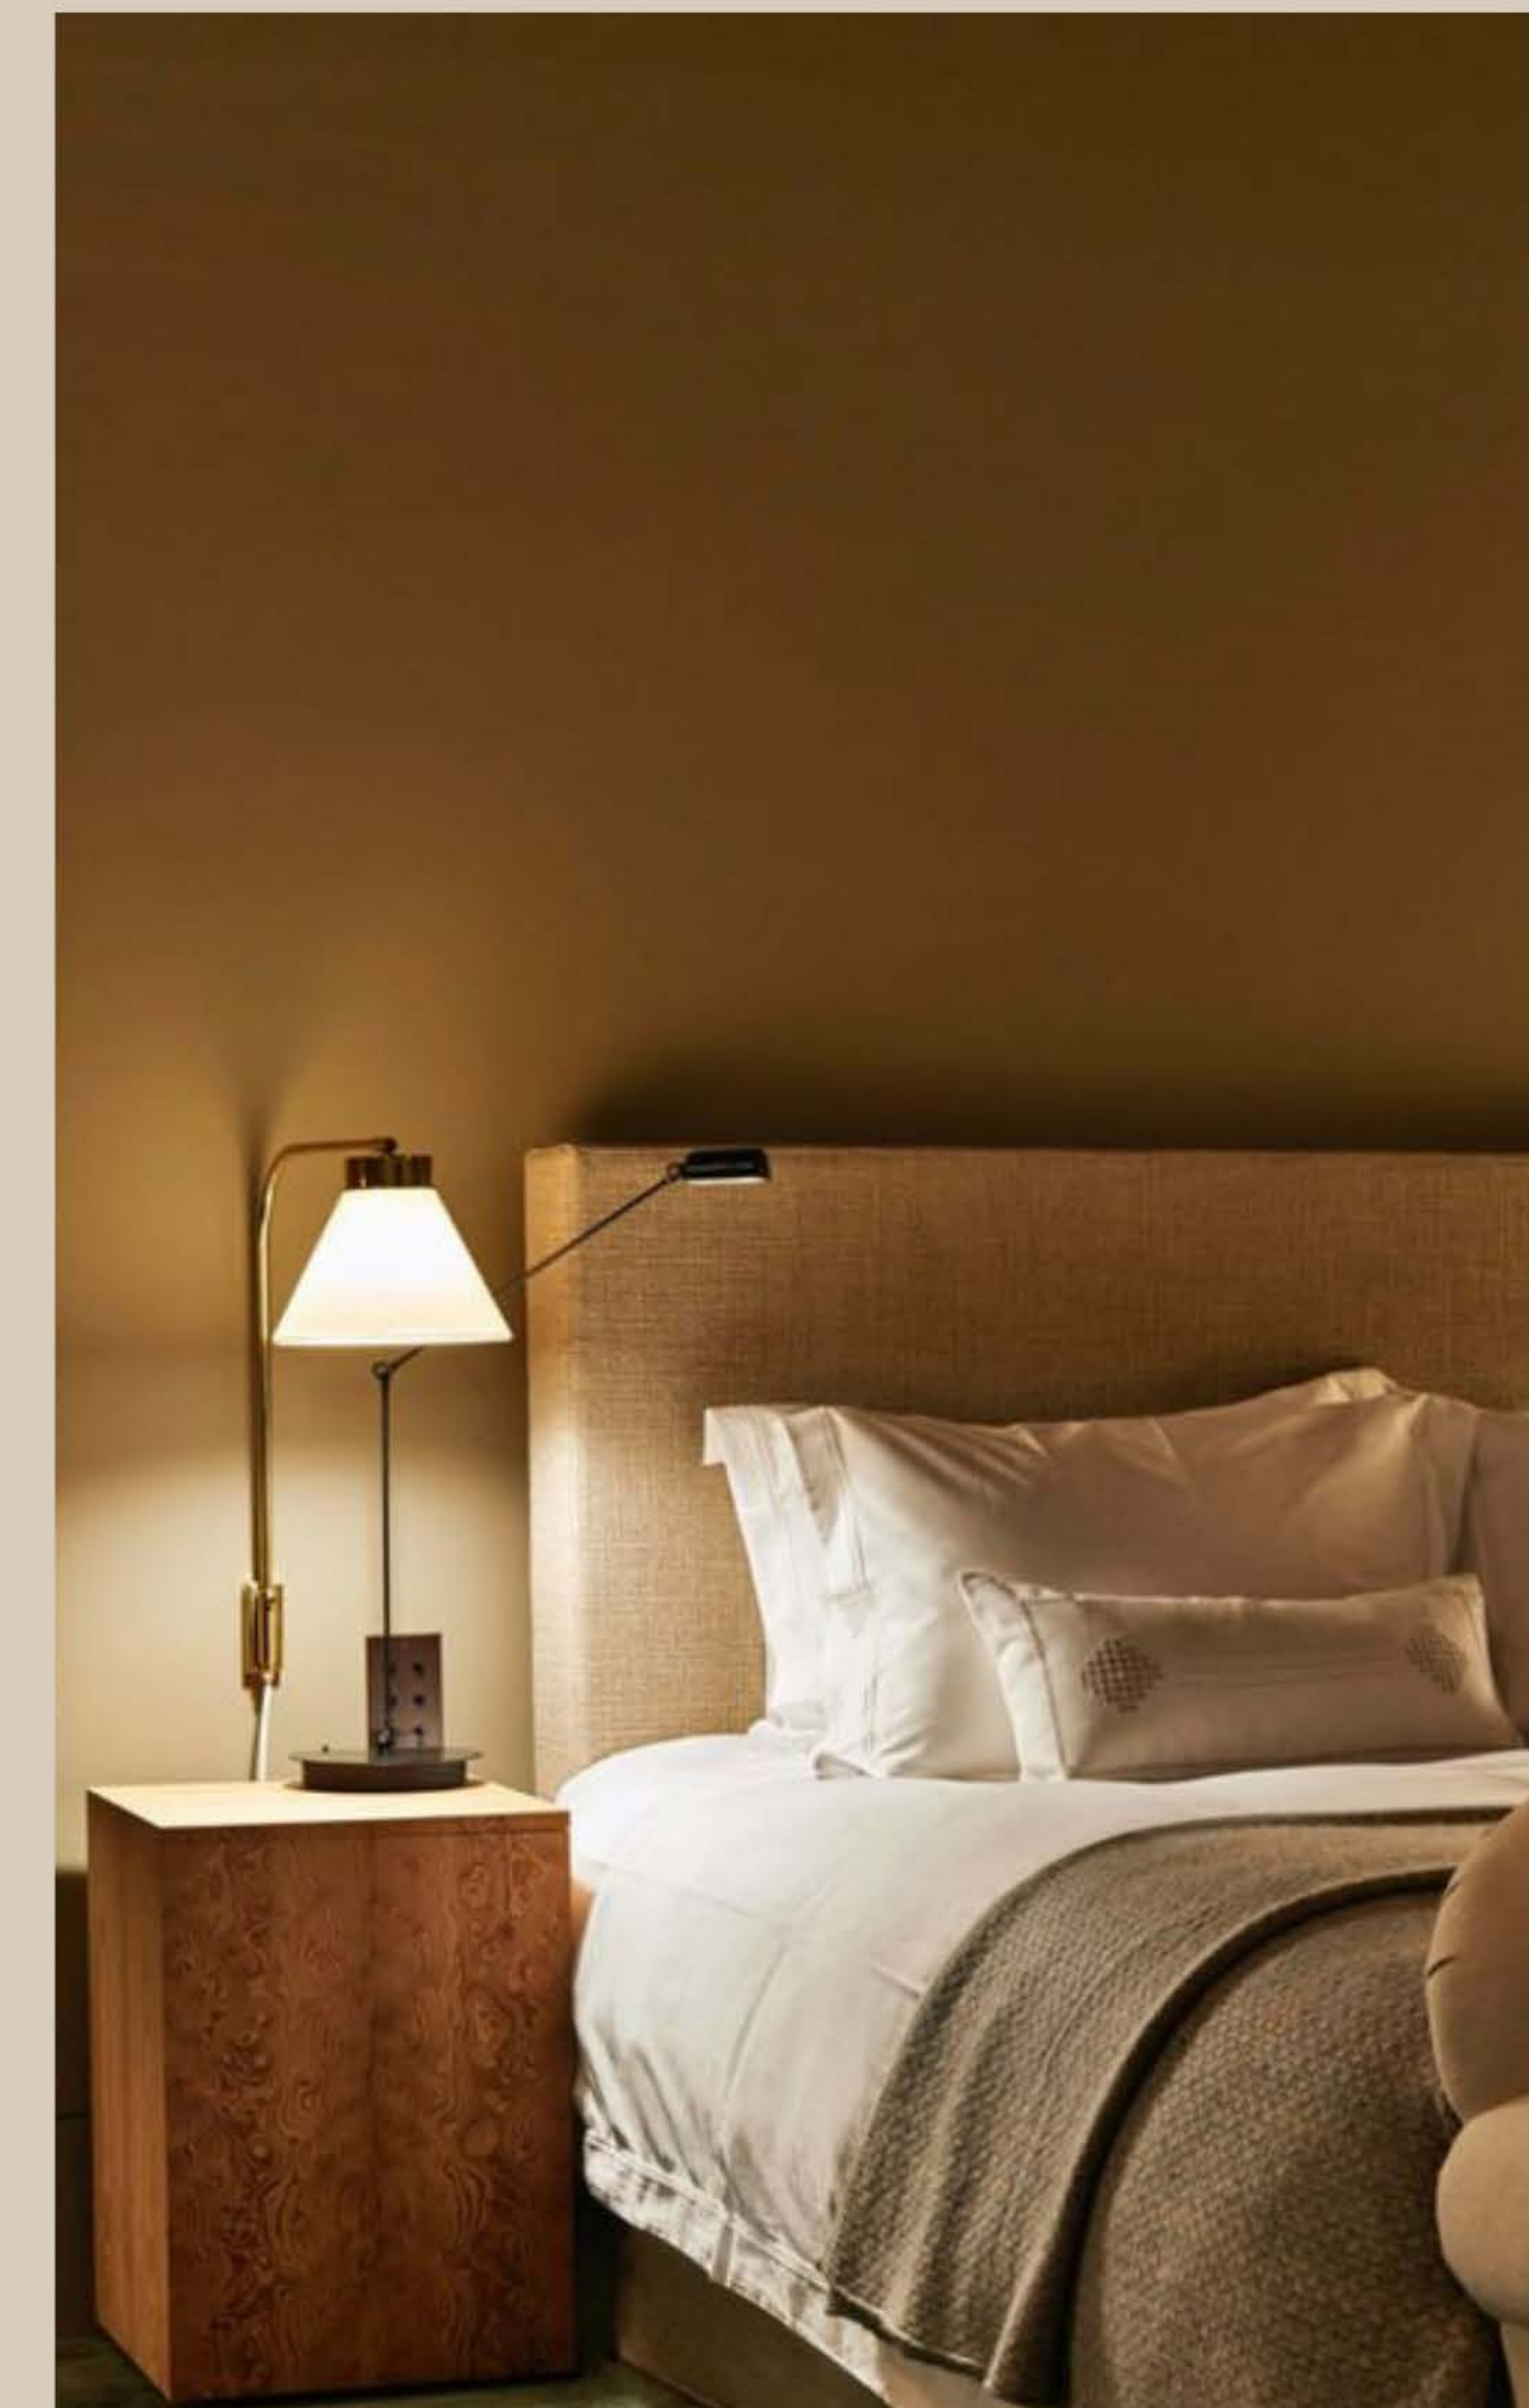

MOOD



PHOTO CRED: BENEDIKT BOLZA

PHOTO CRED: LIGHT AND DWELL

PHOTO CRED: HAM INTERIORS



RUCHED MATERIAL DETAIL

PHOTO CRED: HARLOWE JAMES



PHOTO CRED:FRANCK DURAND



FURNITURE SELECTION


PRIMARY BEDROOM FURNITURE LIST




COLOURS



WALLS

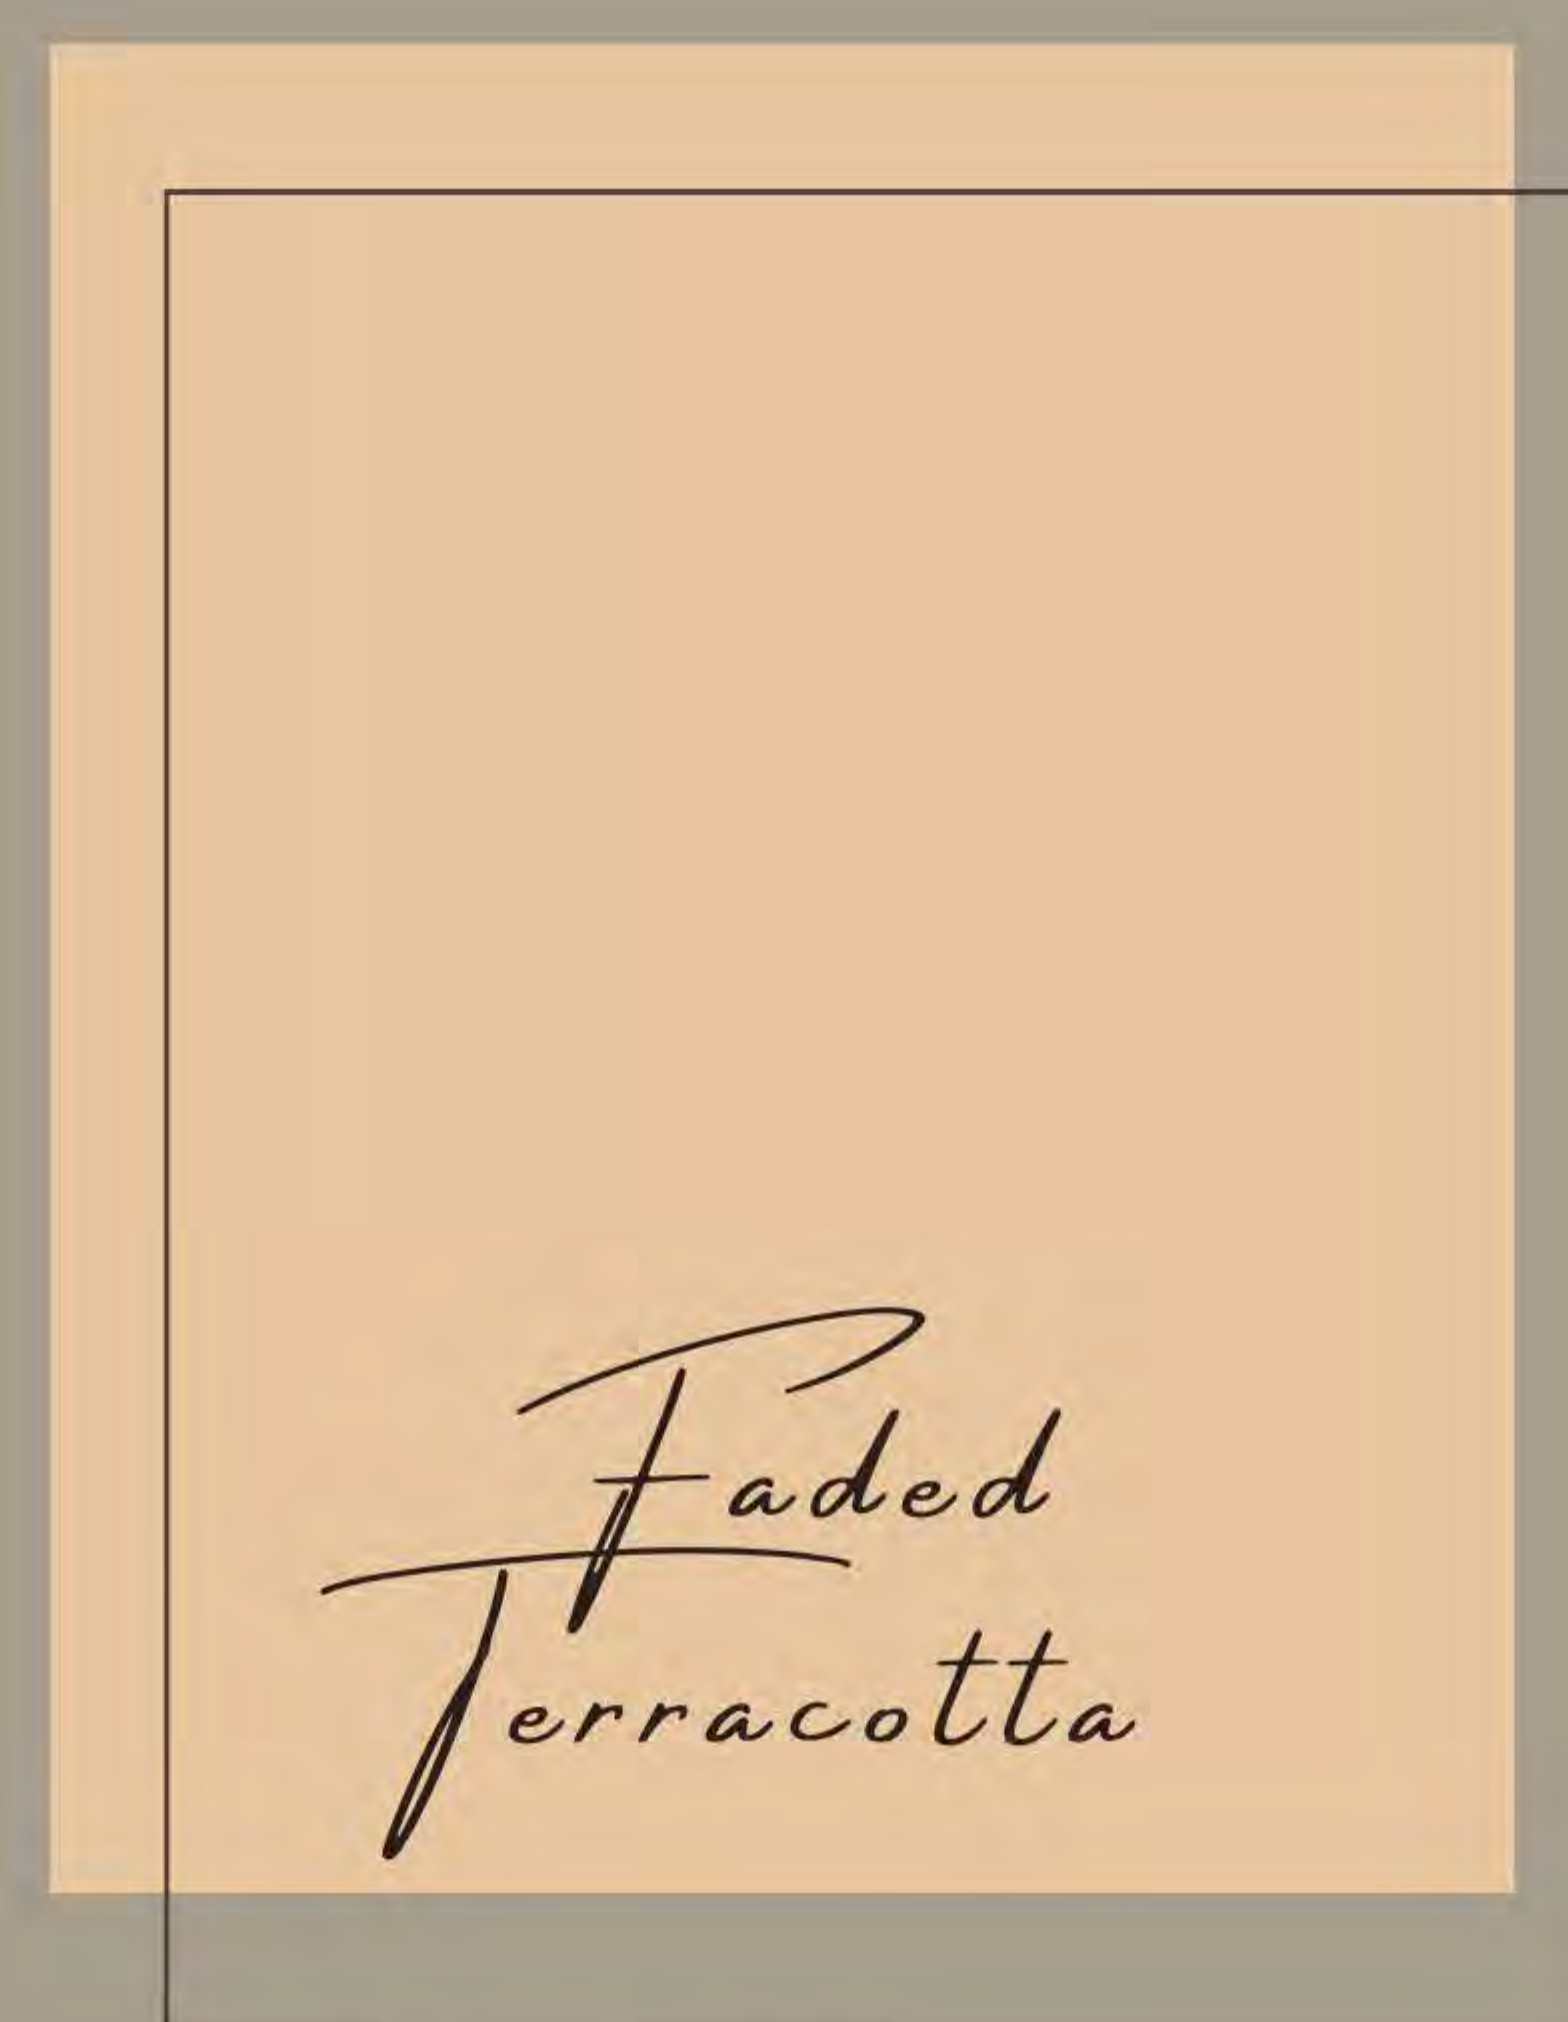

JOINERY

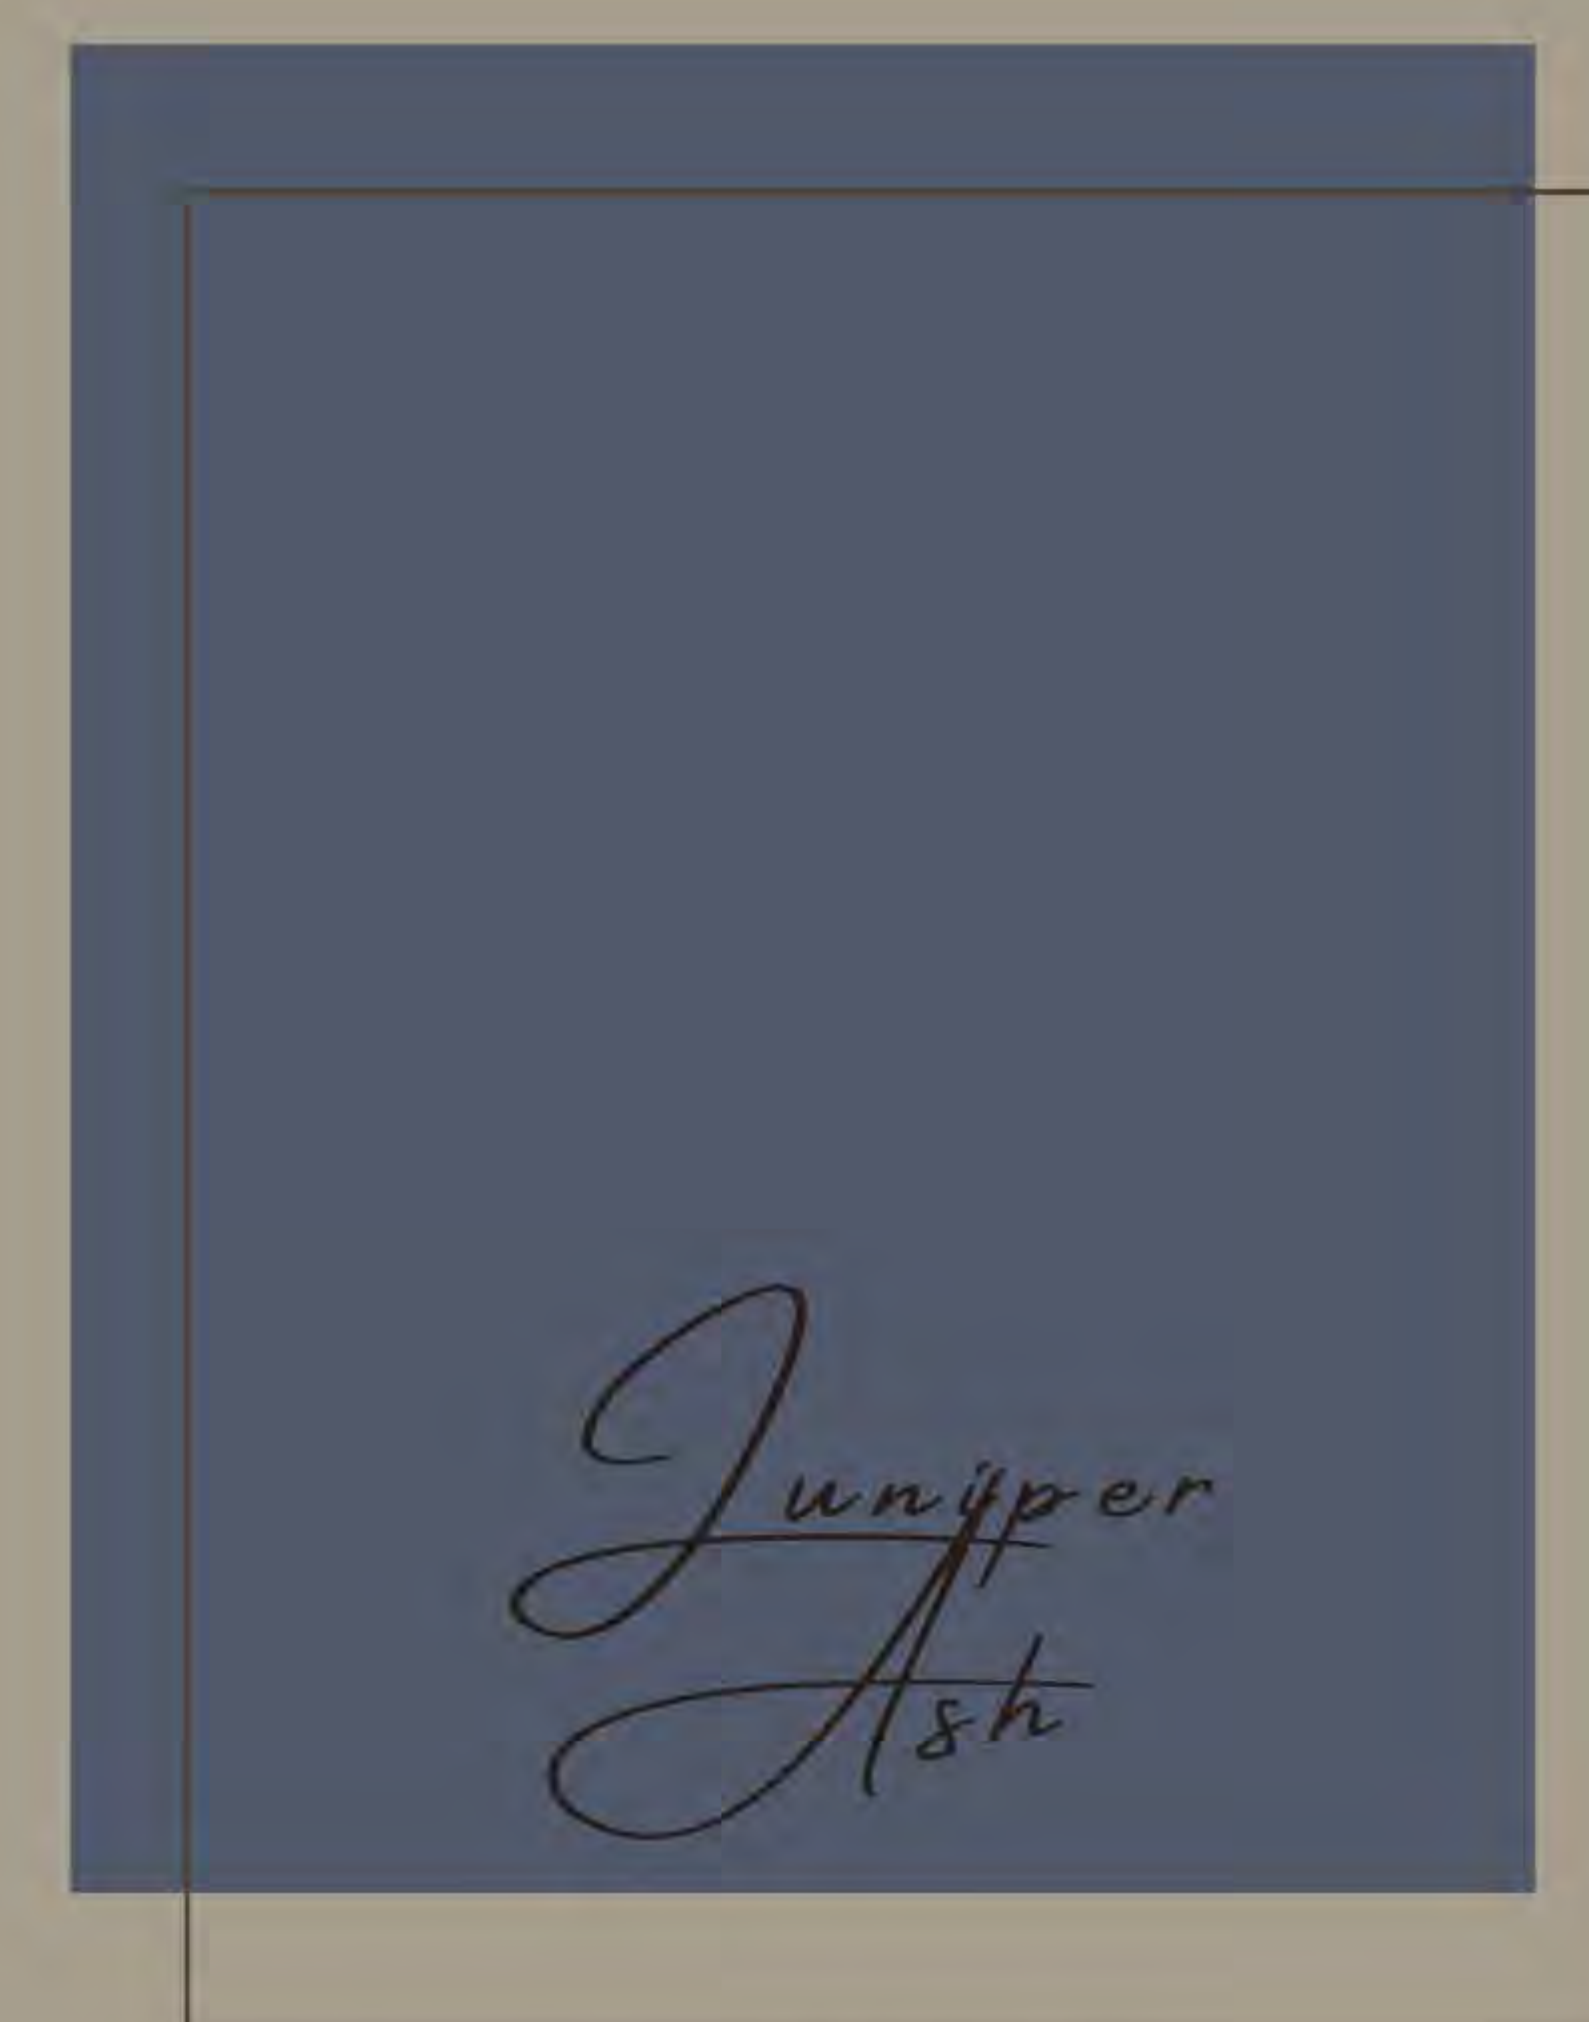

SKIRTING &
DOORS

MATERIALS

LIGHT SHADE:
Ikat print




RUG
Hand Woven Jute & Wool



FLOORING:
Walnut stained wood




PENDANT:
Sand Linen Shade

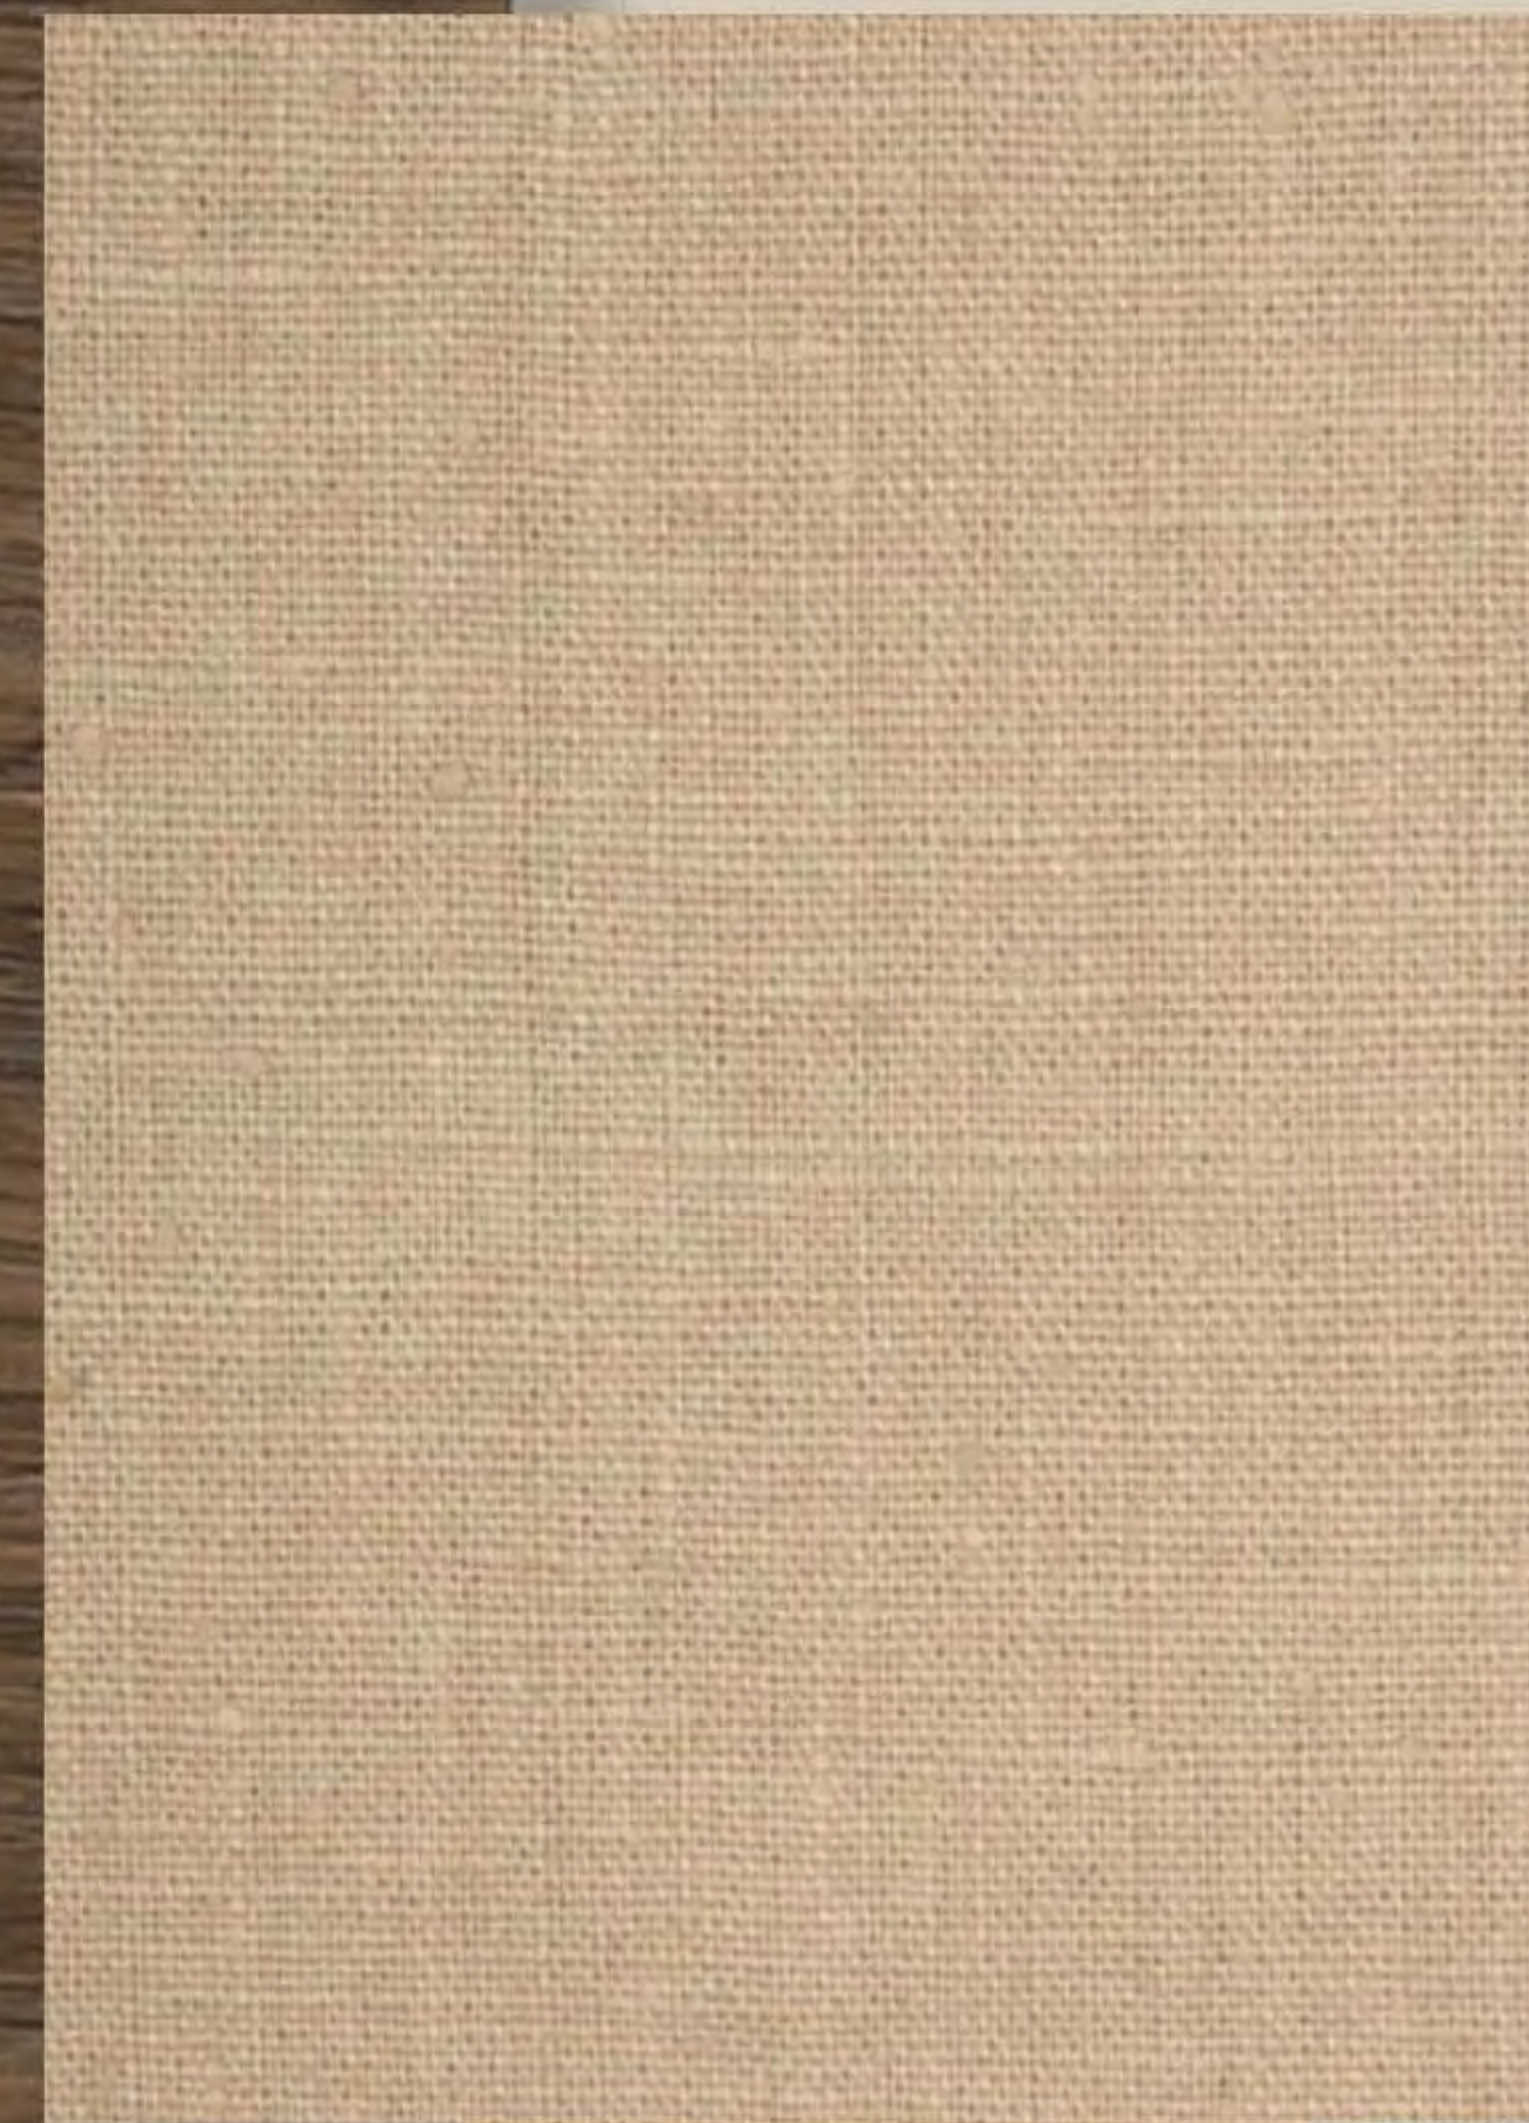

BED:
Velvet Upholstered



SCATTER:
Light mustard velvet

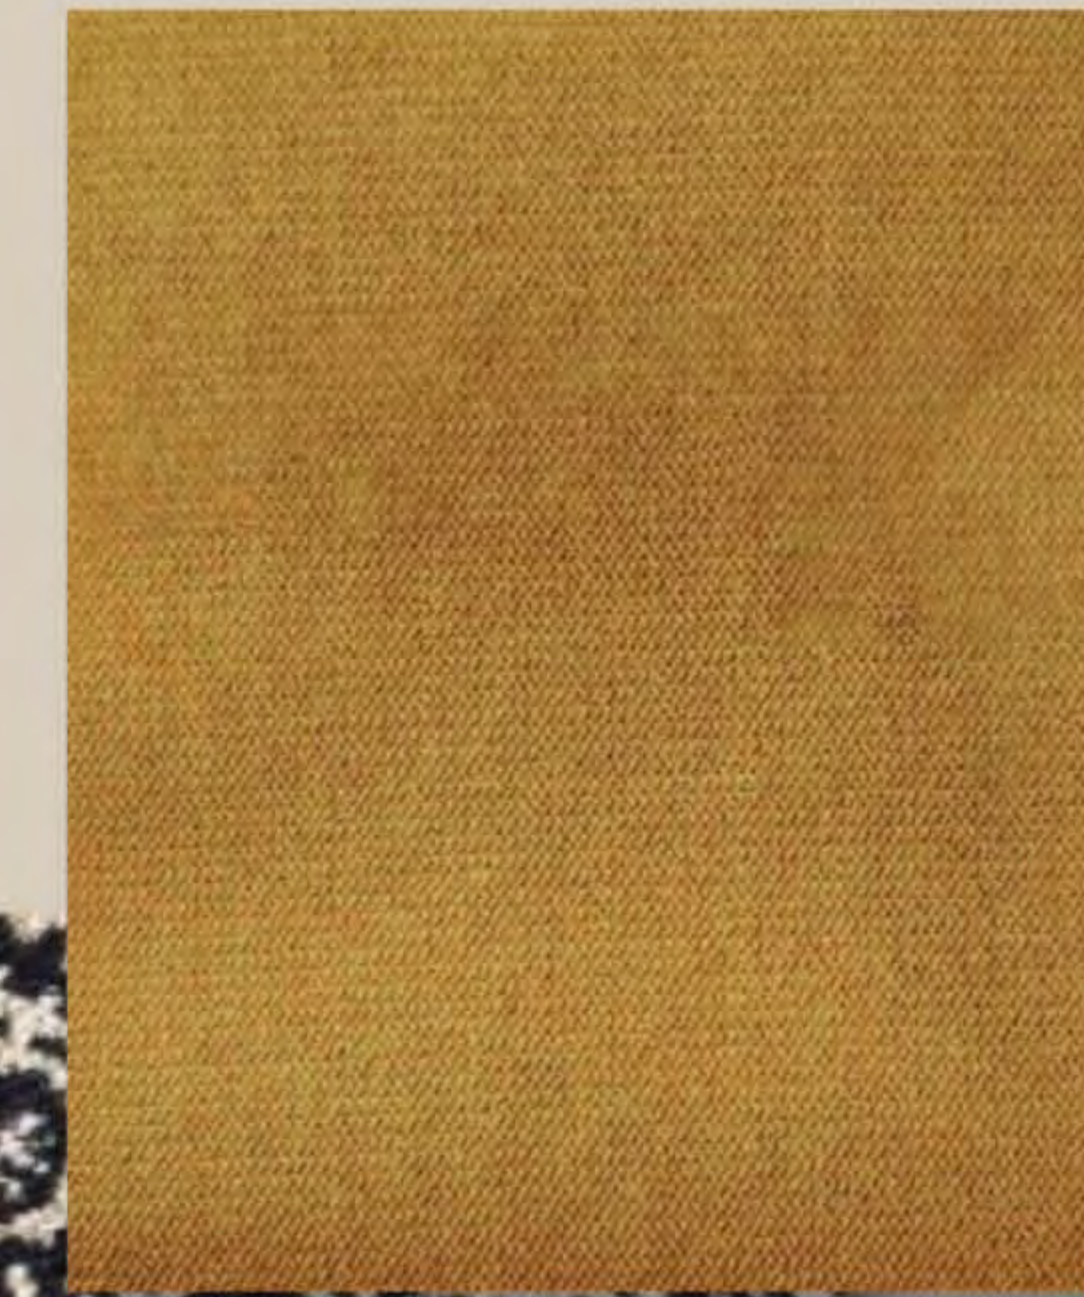

CURTAIN:
Pattern Fabric



BEDDING:
White Muslin Fabric




ELEVATIONS

PRIMARY BEDROOM




BED ELEVATION

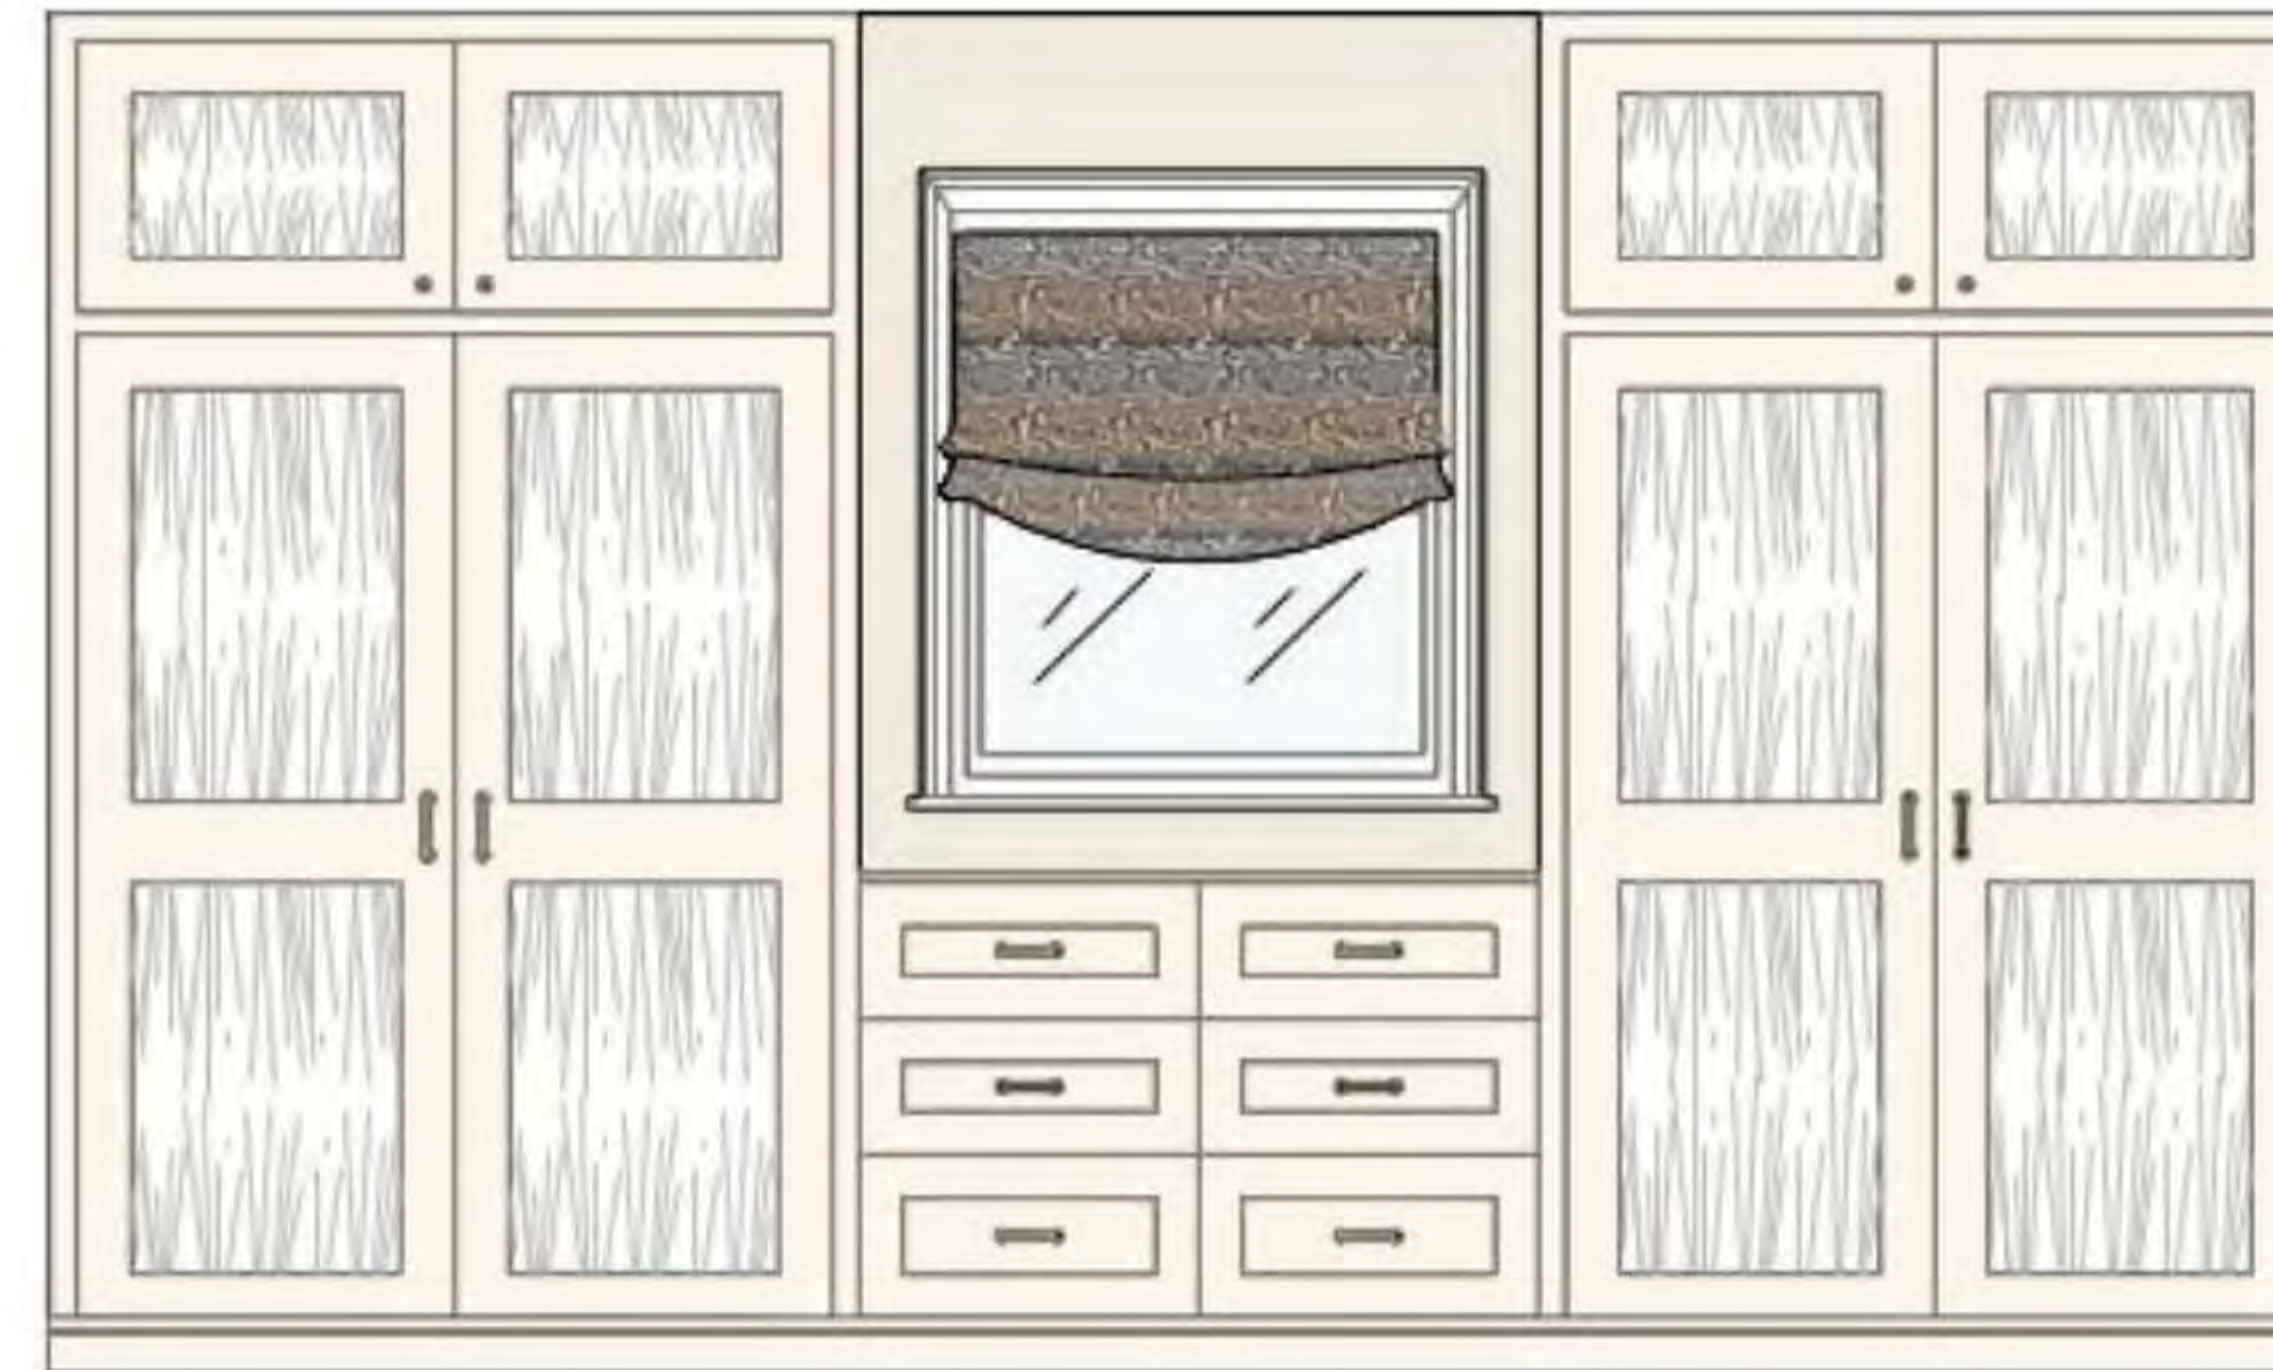

WARDROBE &
DRESSING TABLE
ELEVATION



INTERNAL
WARDROBE
ELEVATION

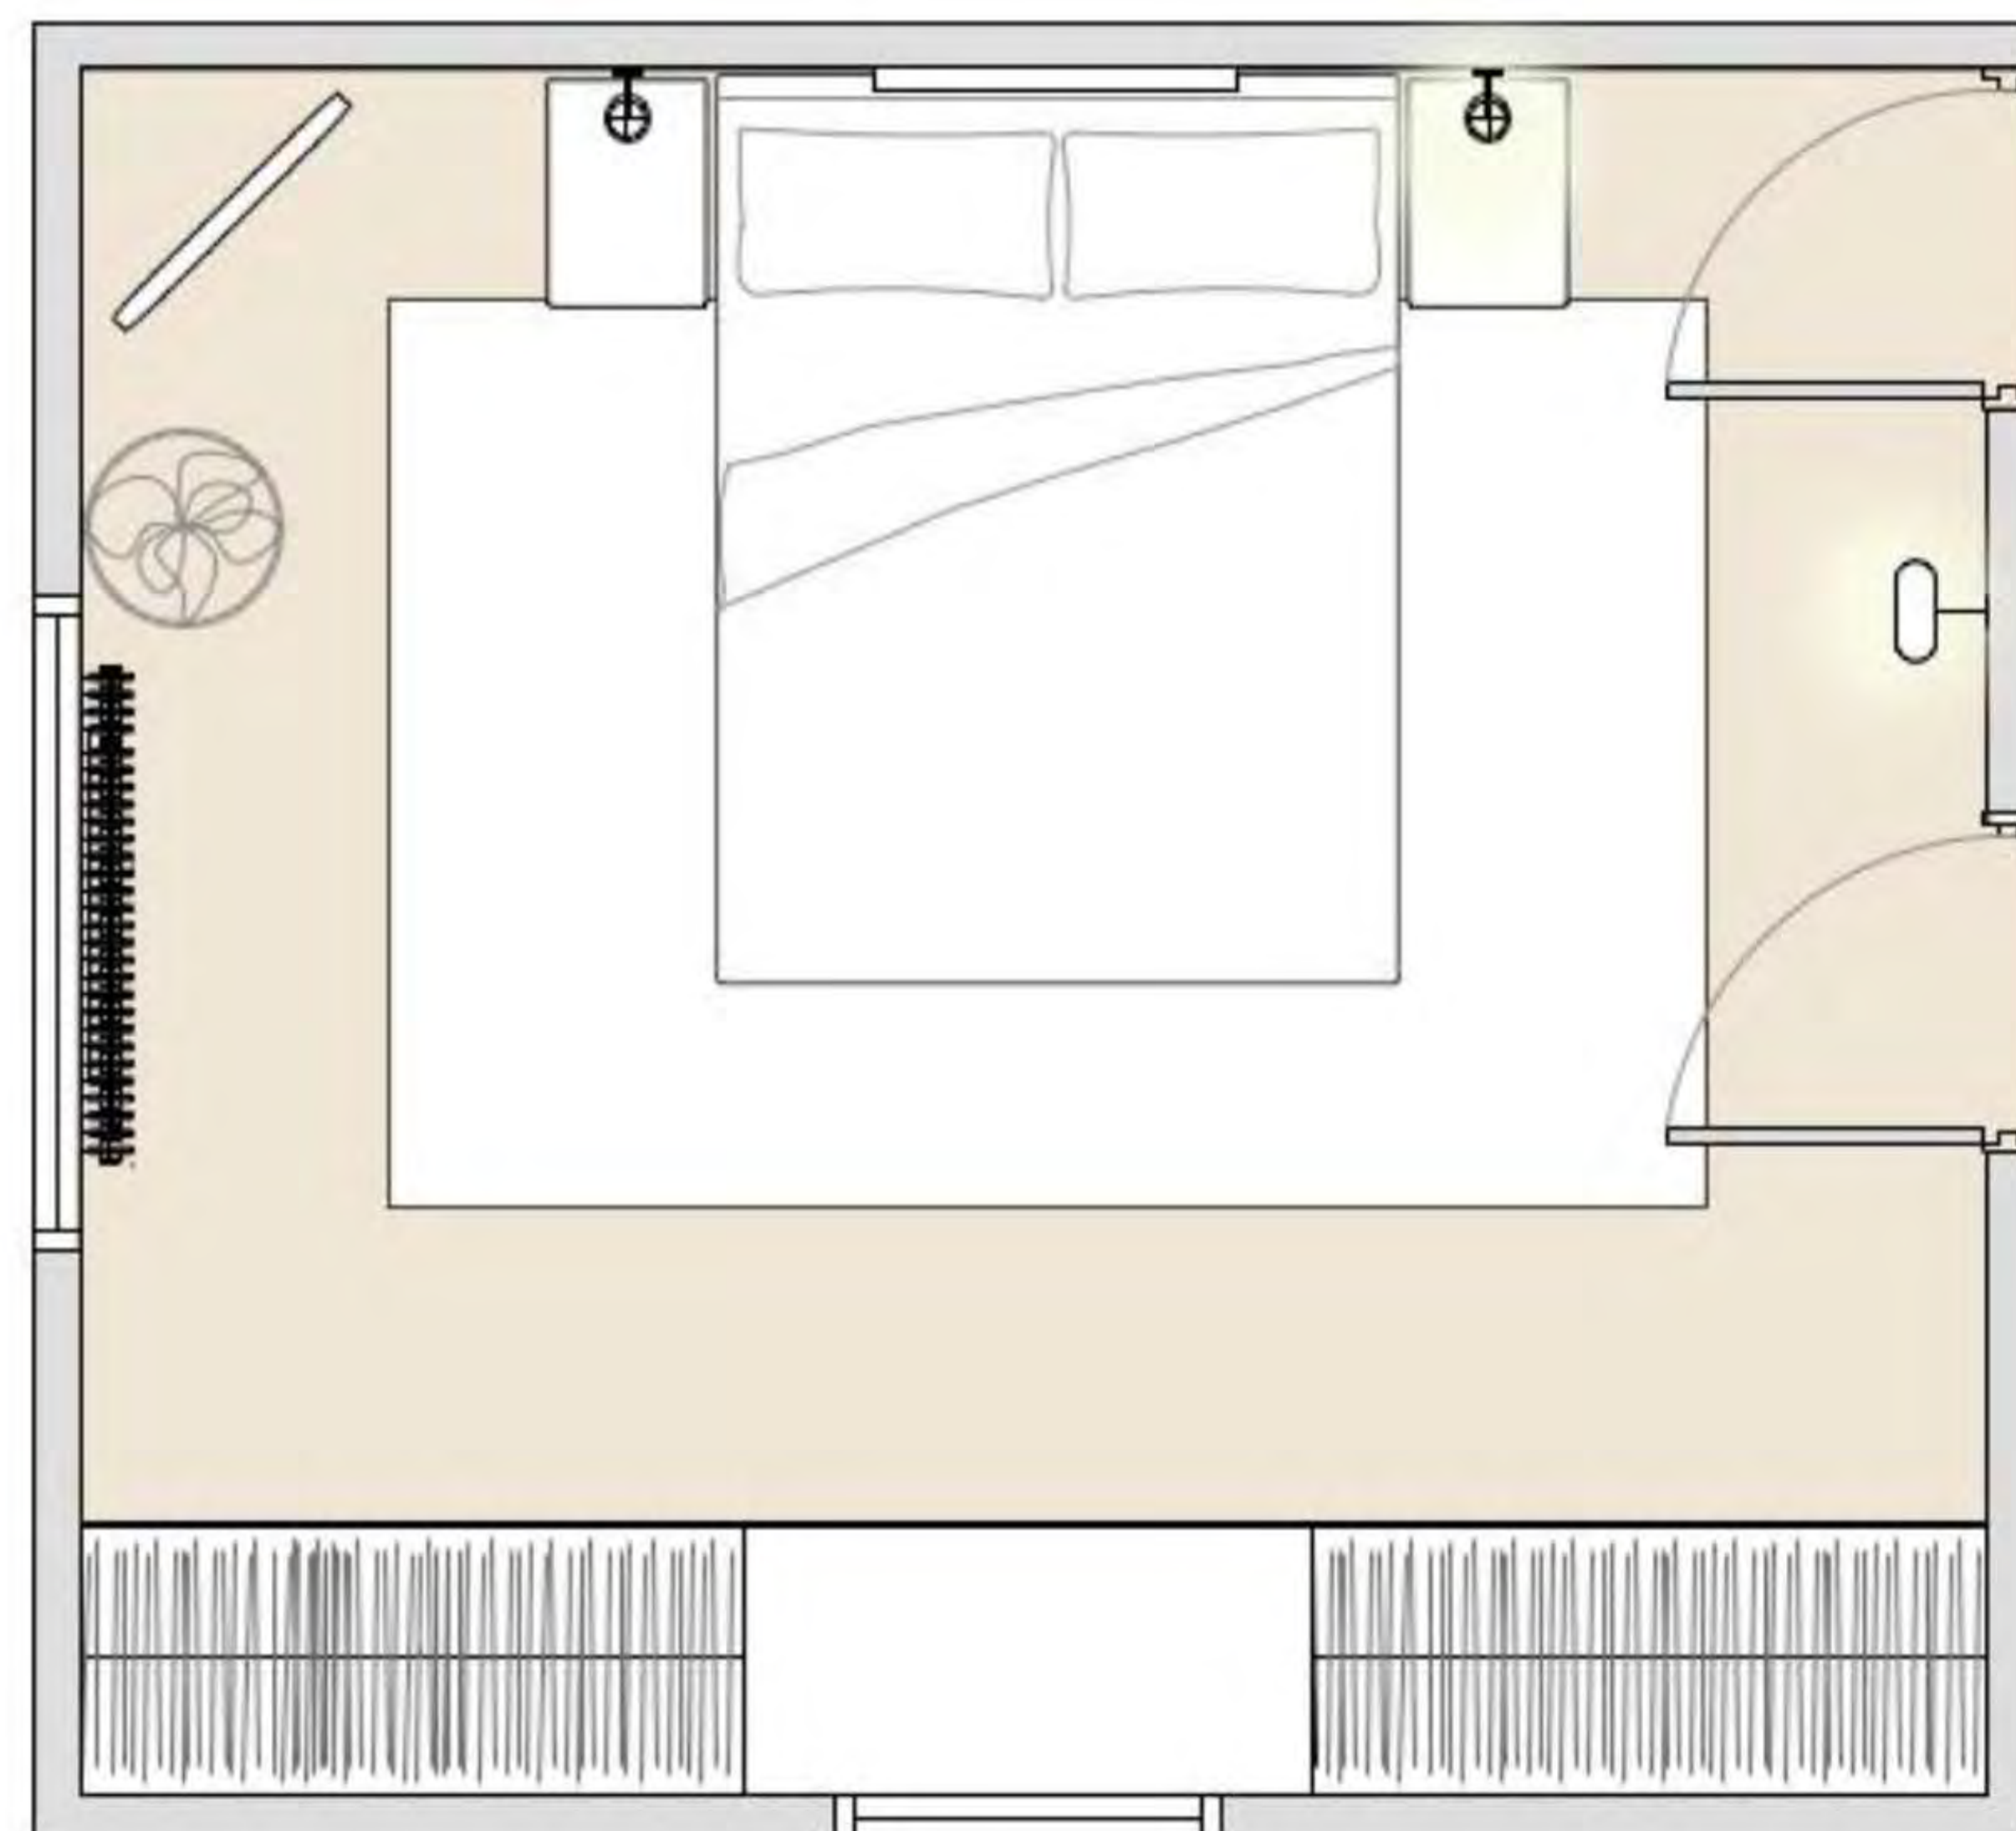


FLOOR PLAN

BESPOKE JOINERY


Kitchen

Ground Floor


EXTERNAL WARDROBE

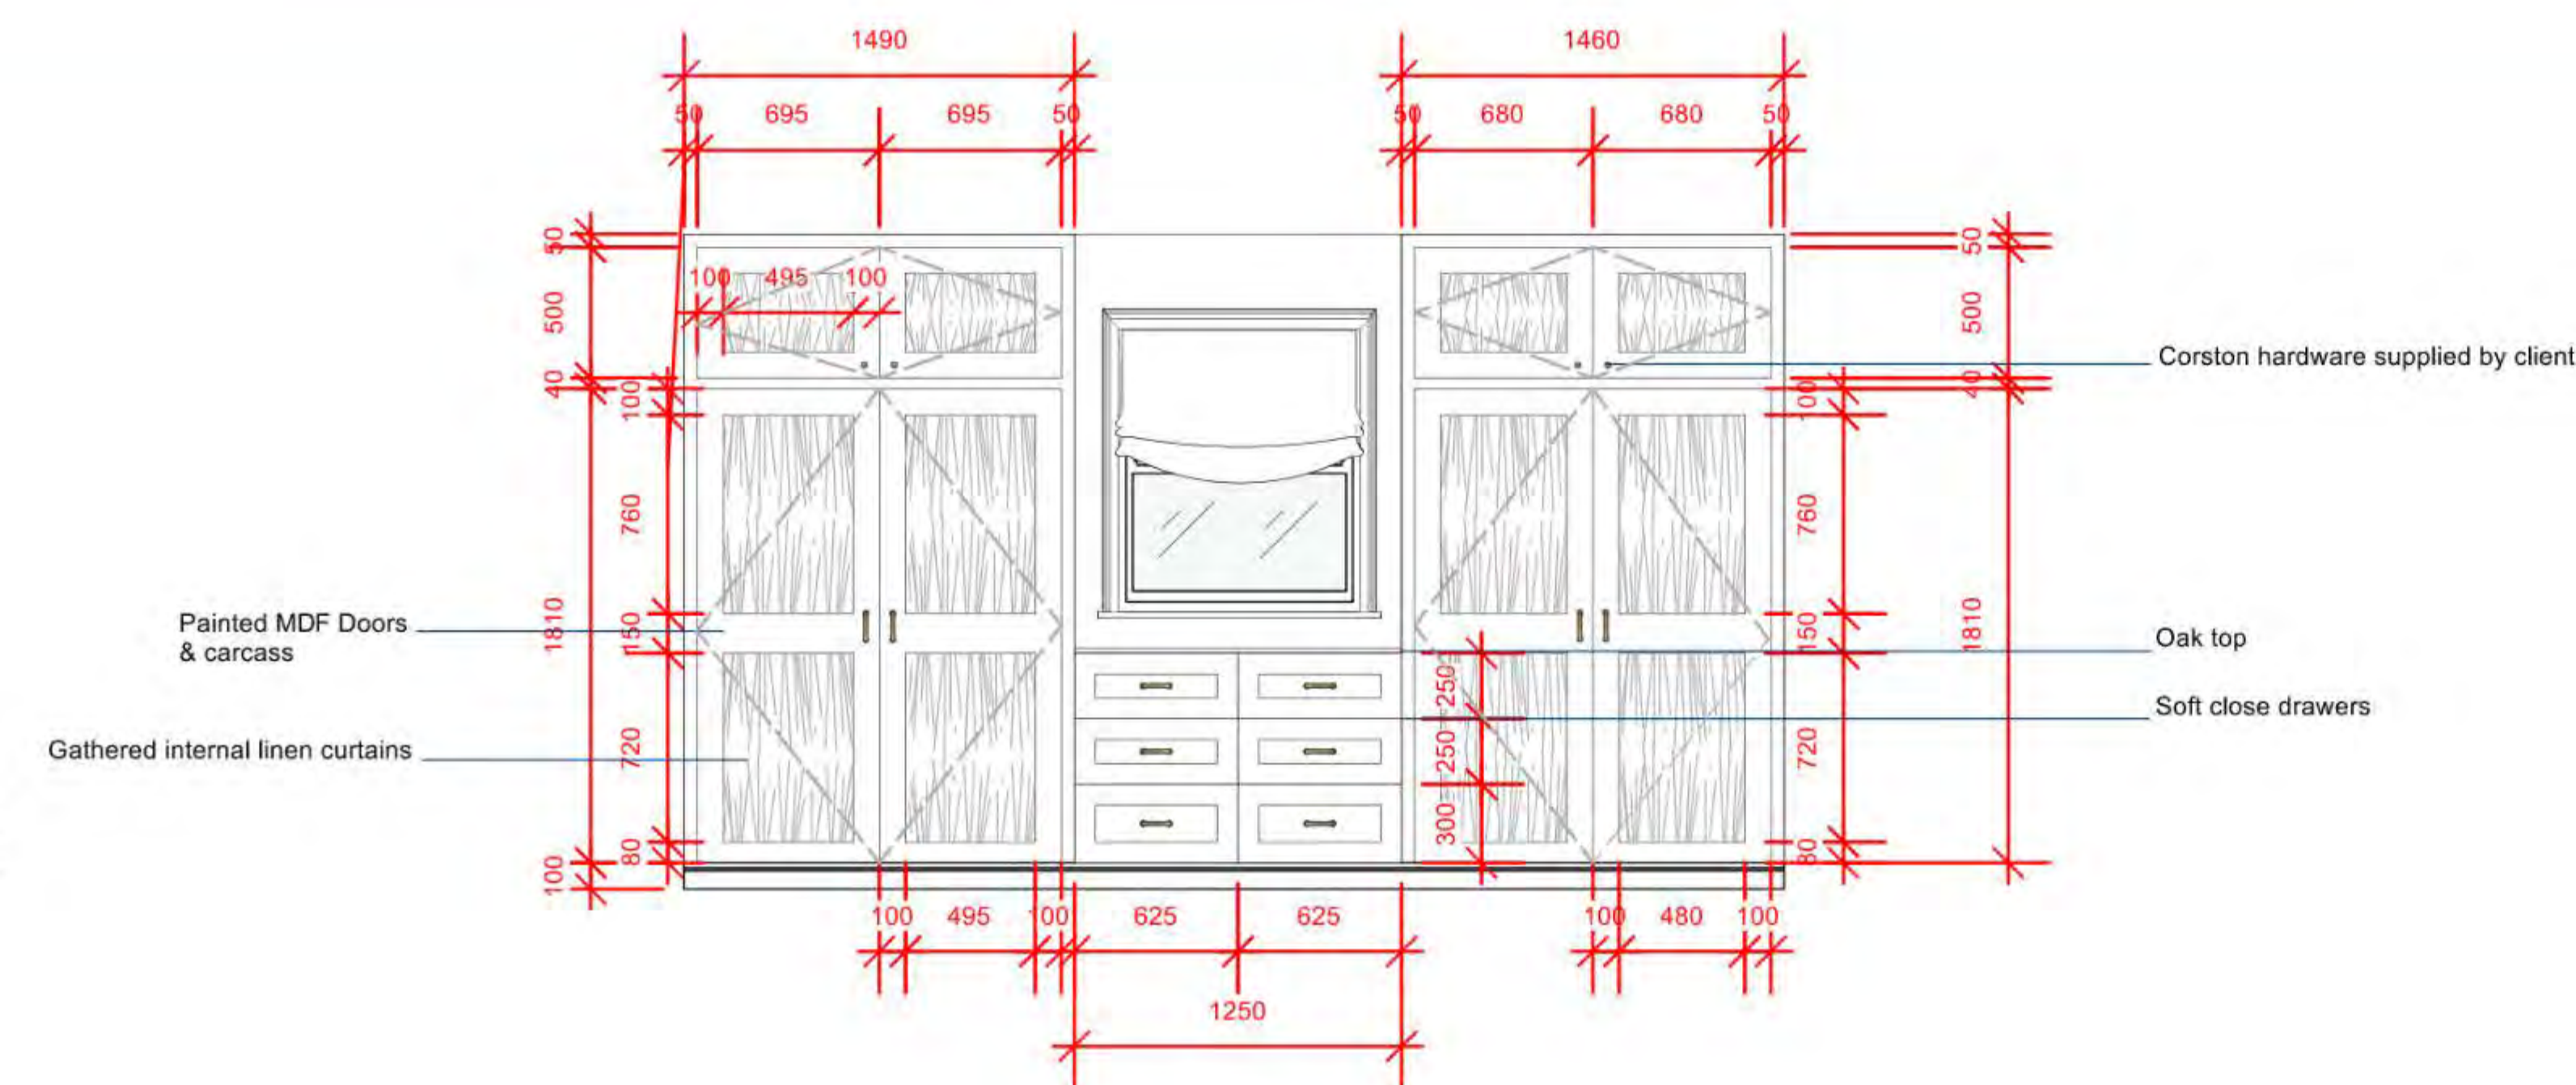

INTERNAL WARDROBE

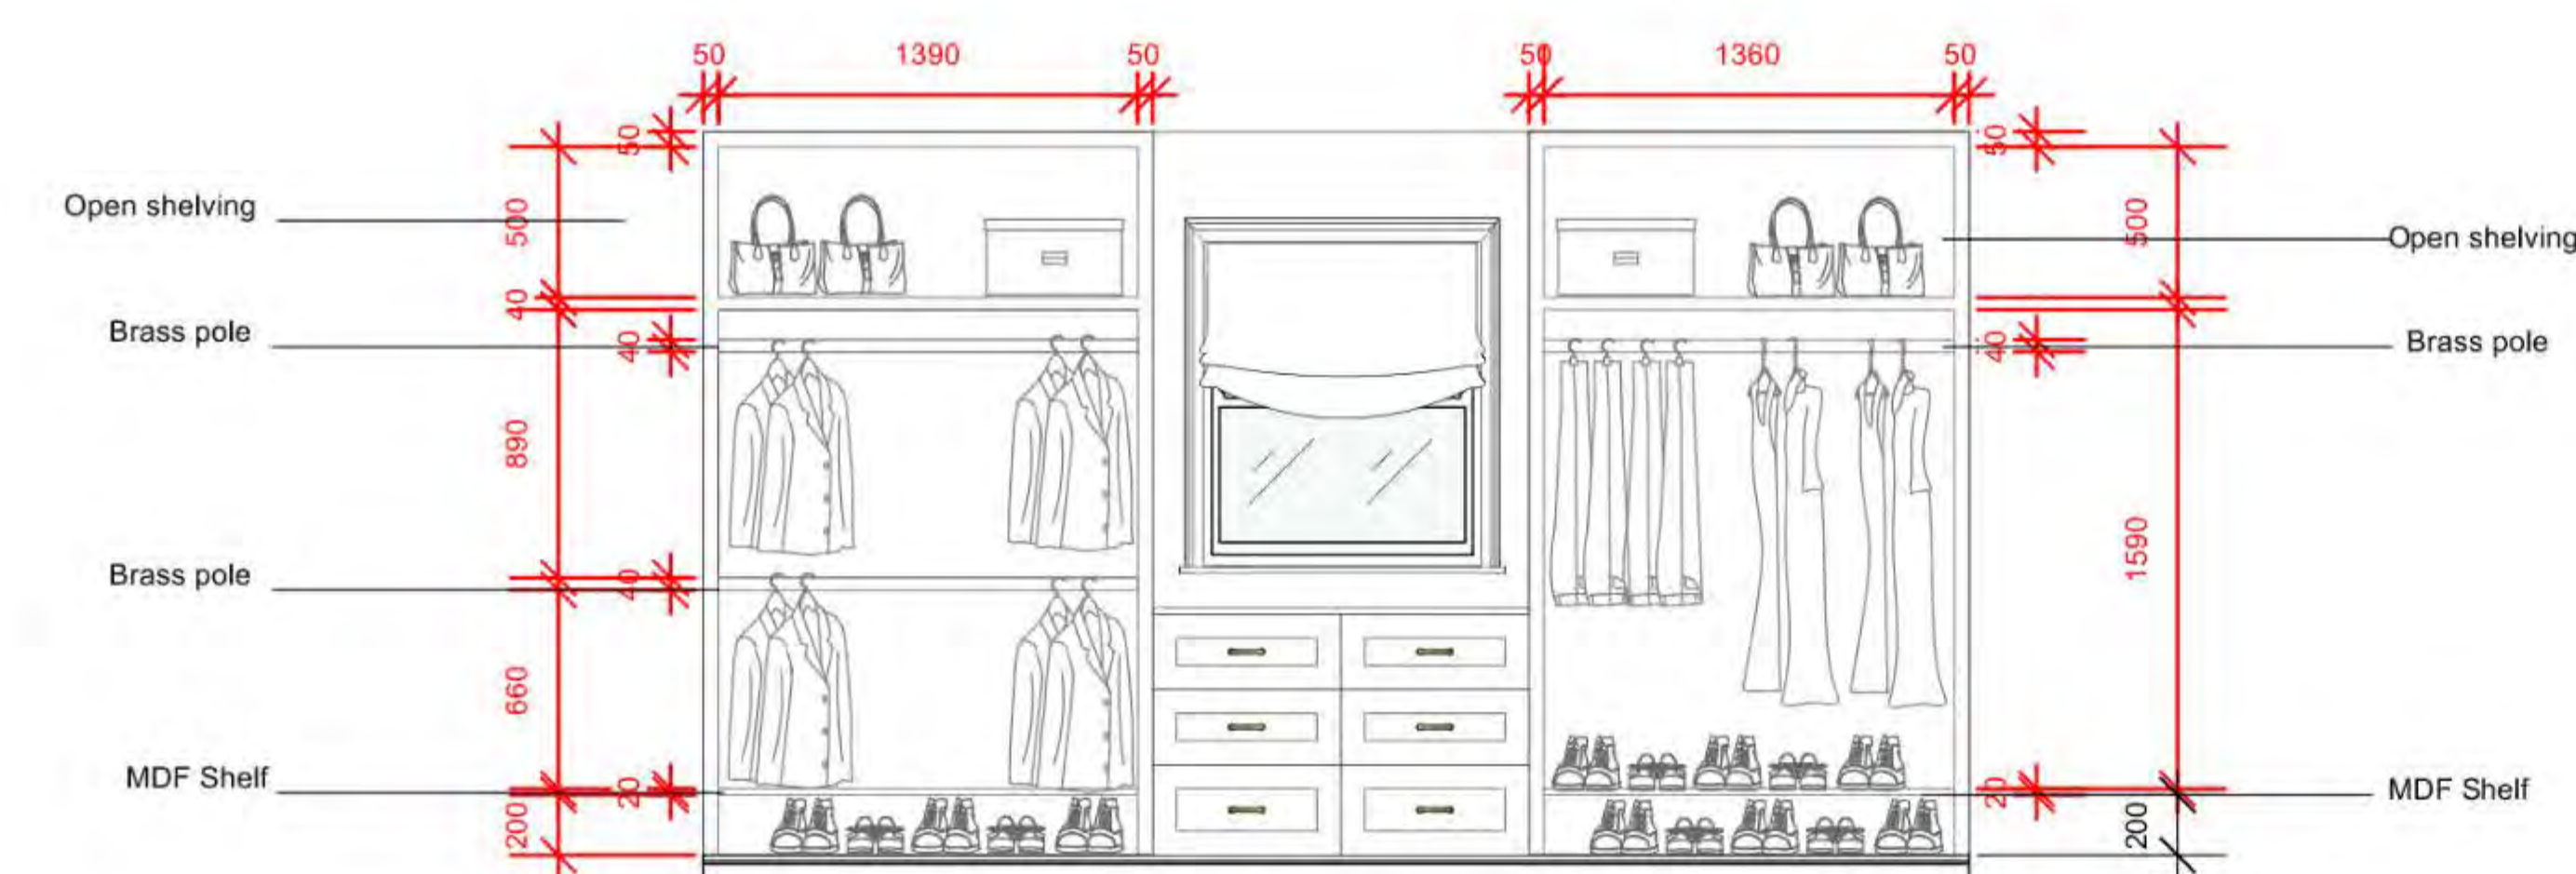

FLOOR PLAN

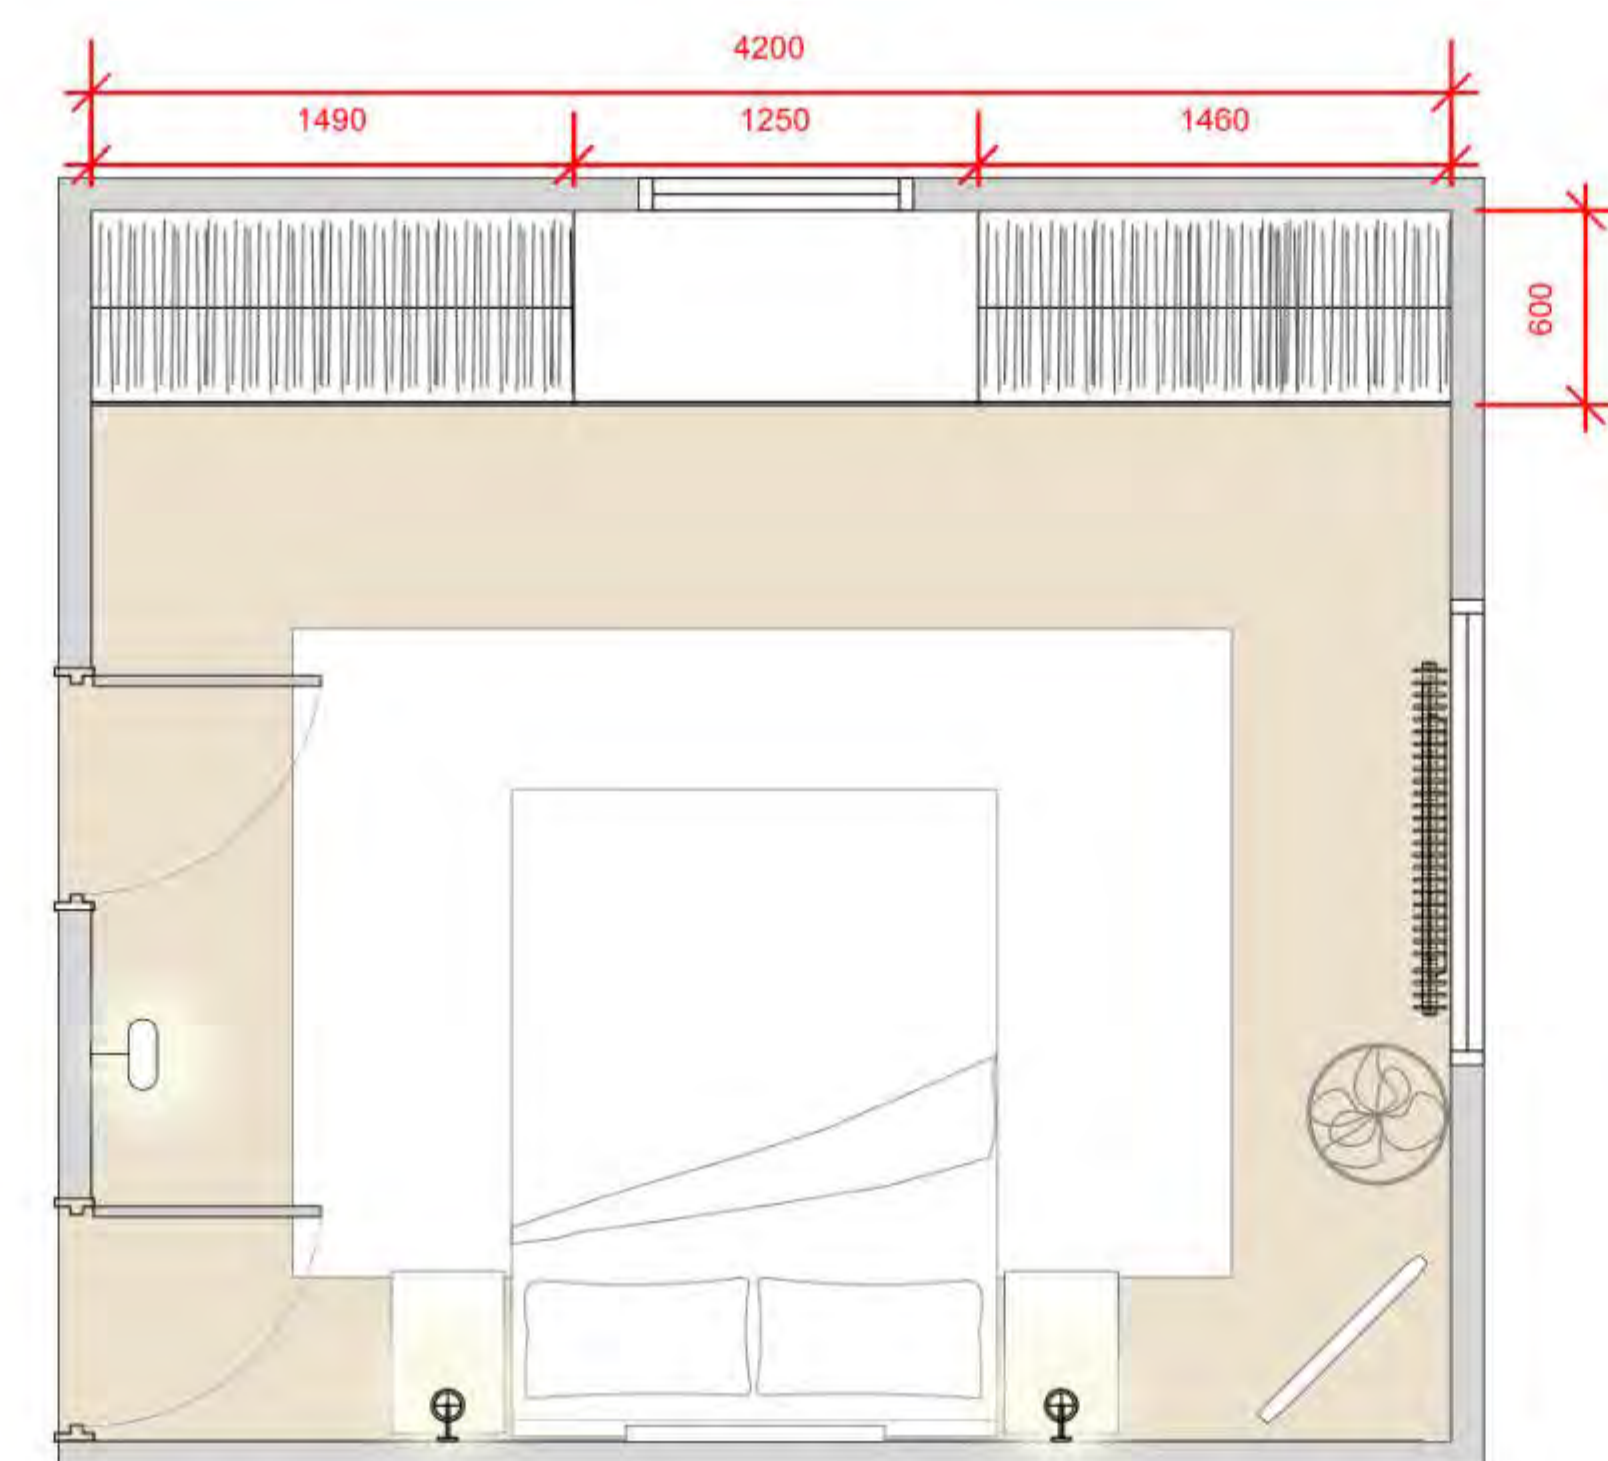

Project
Bakewell Bedroom

Project Number
1000

Issue Date
09/03/24

Paper Scale
@ A3
1:50

Drawing No.

101

Revision/ Notes:

Note**

This drawing is for illustrative purposes only. All drawings are not for construction unless specifically marked for this purpose.

All dimensions on this drawing are for reference ONLY. Contractor and joiner required to measure the site and use their own dimensions for ALL setting out and construction. Any site anomalies to be discussed with Architect/ Camila Carmen before proceeding with the works.

Camila Carmen Interiors

49 XXX Road, London, XXXX
Phone +44 (0) XXXXXX

www.camilacarmeninteriors.com
camila@camilacarmeninteriors.com



DOORS
Painted MDF

WORKTOP
Oak


HANDLES
Antique Brass

CUSTOM CURTAINS

Relaxed Roman
Blind


Primary Bedroom

CURTAIN FABRIC

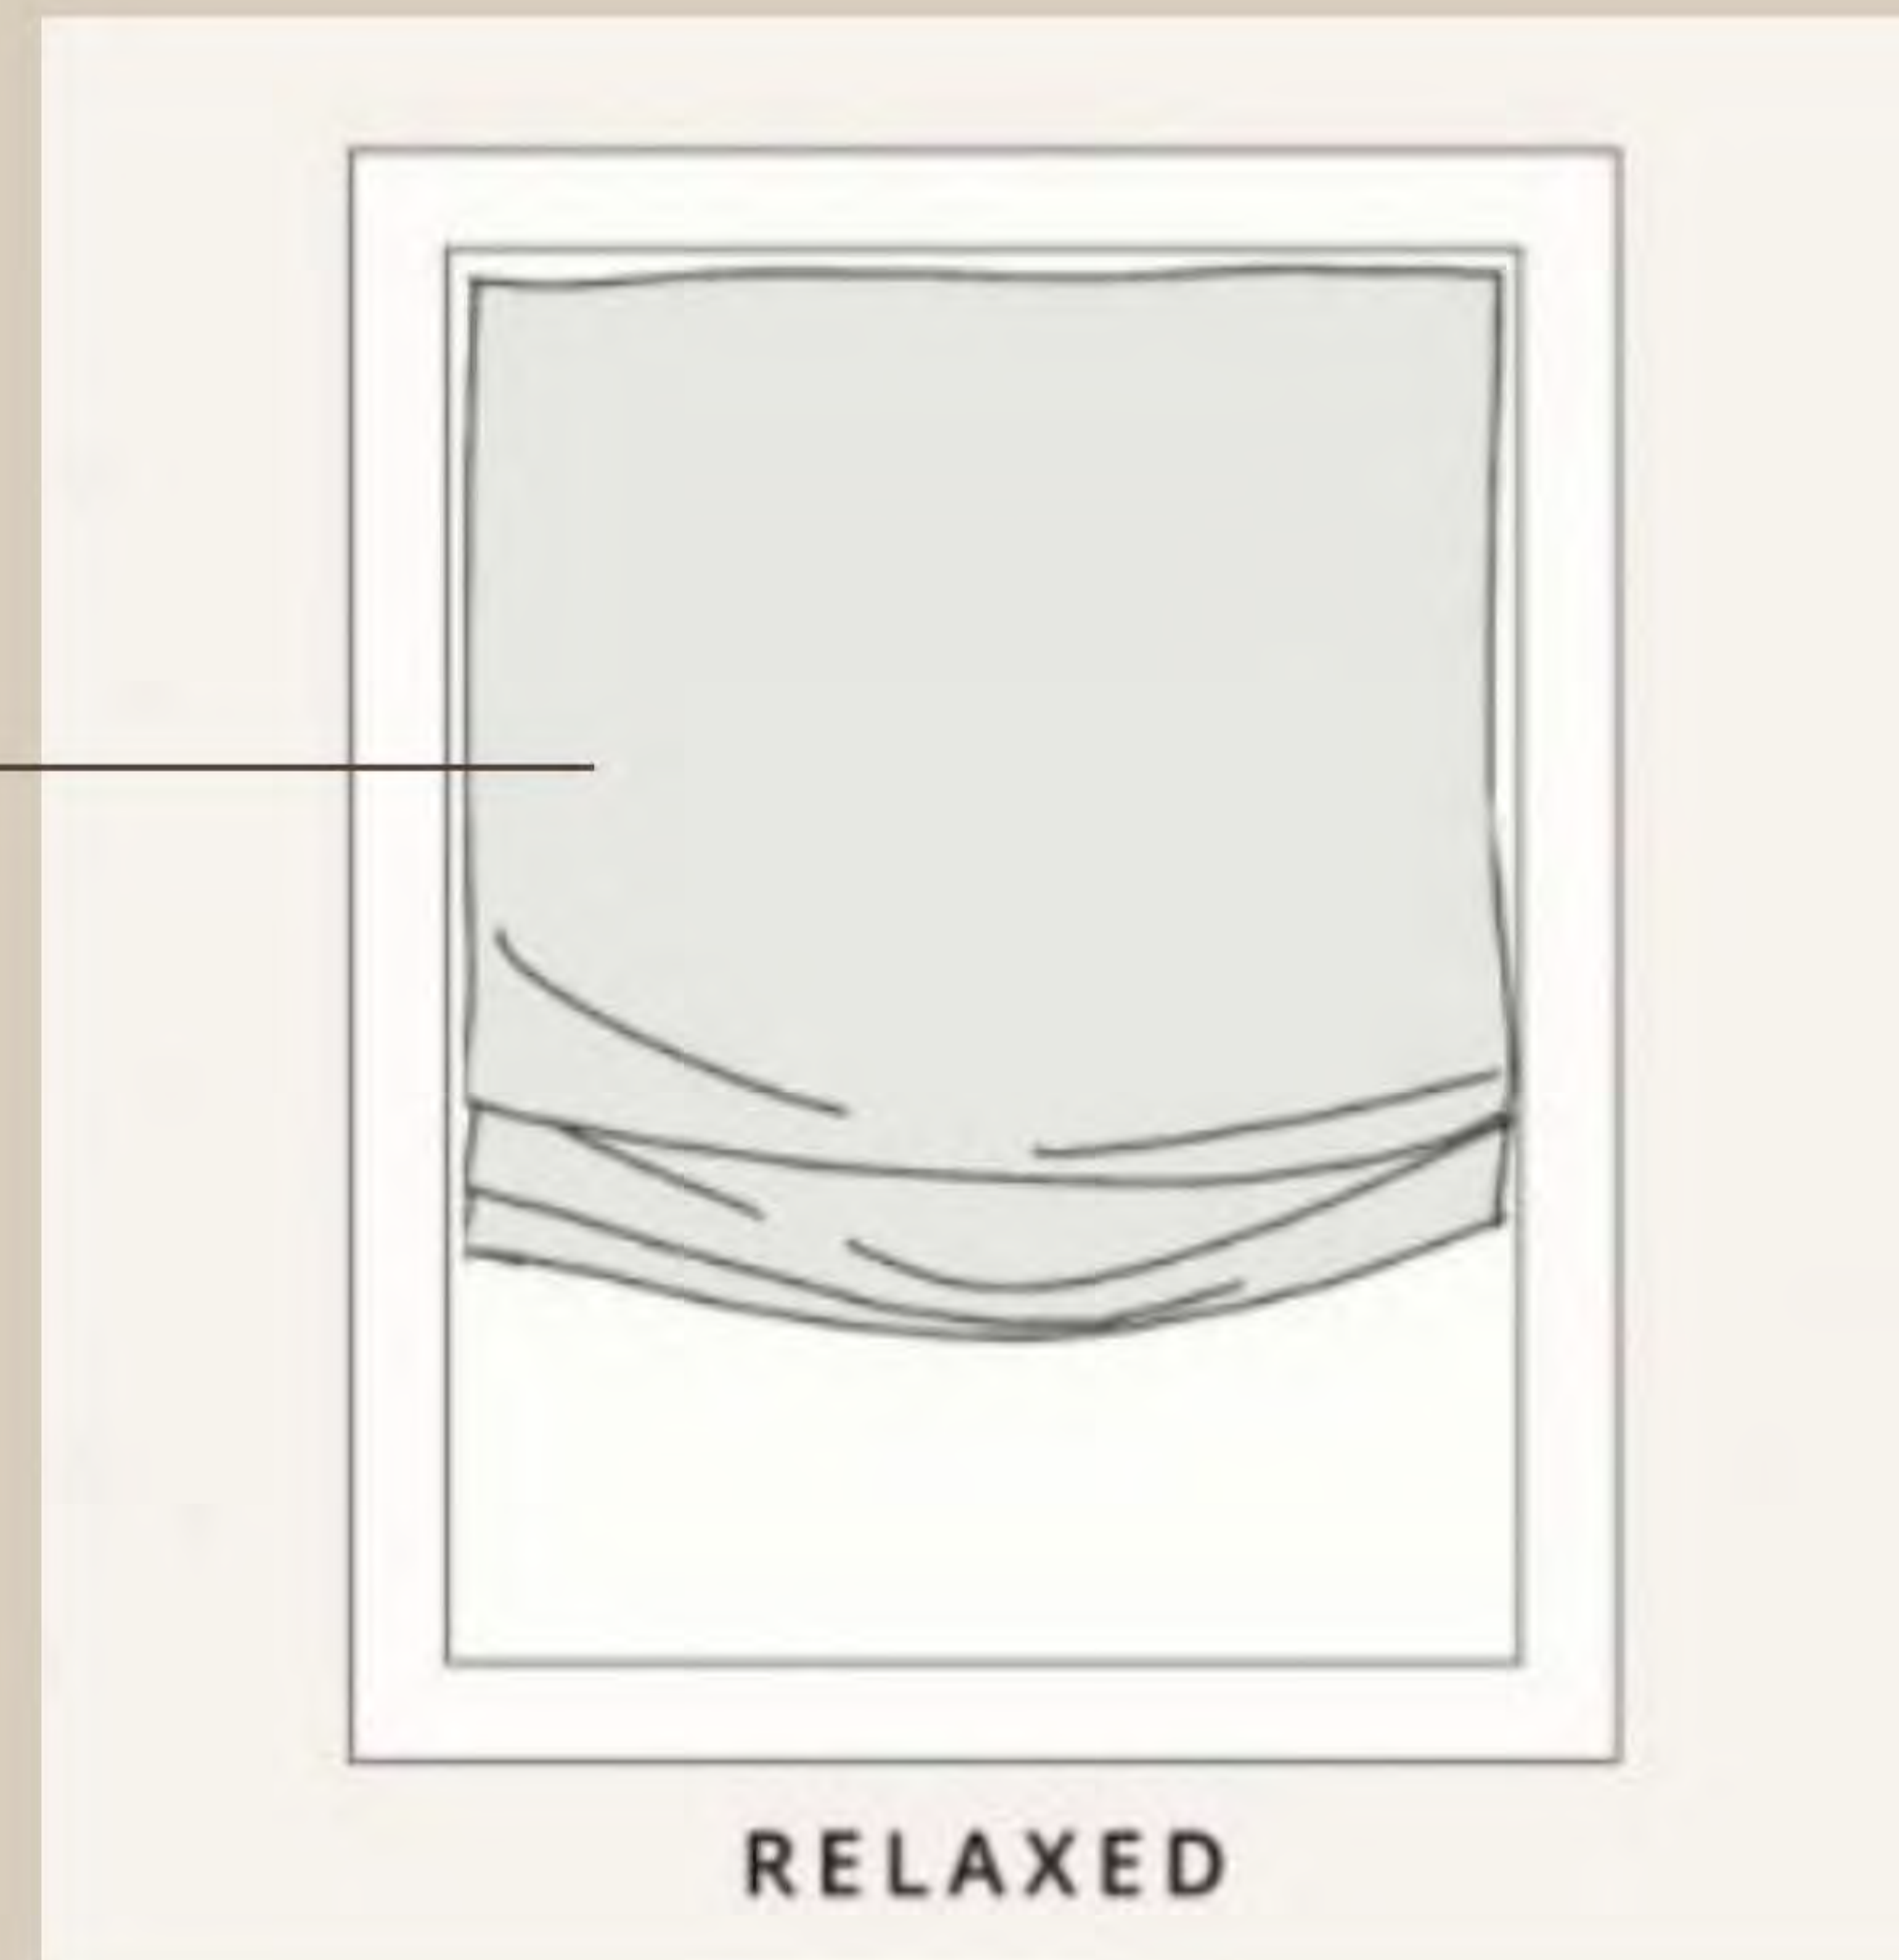

LIGHTING PLAN


PRIMARY BEDROOM

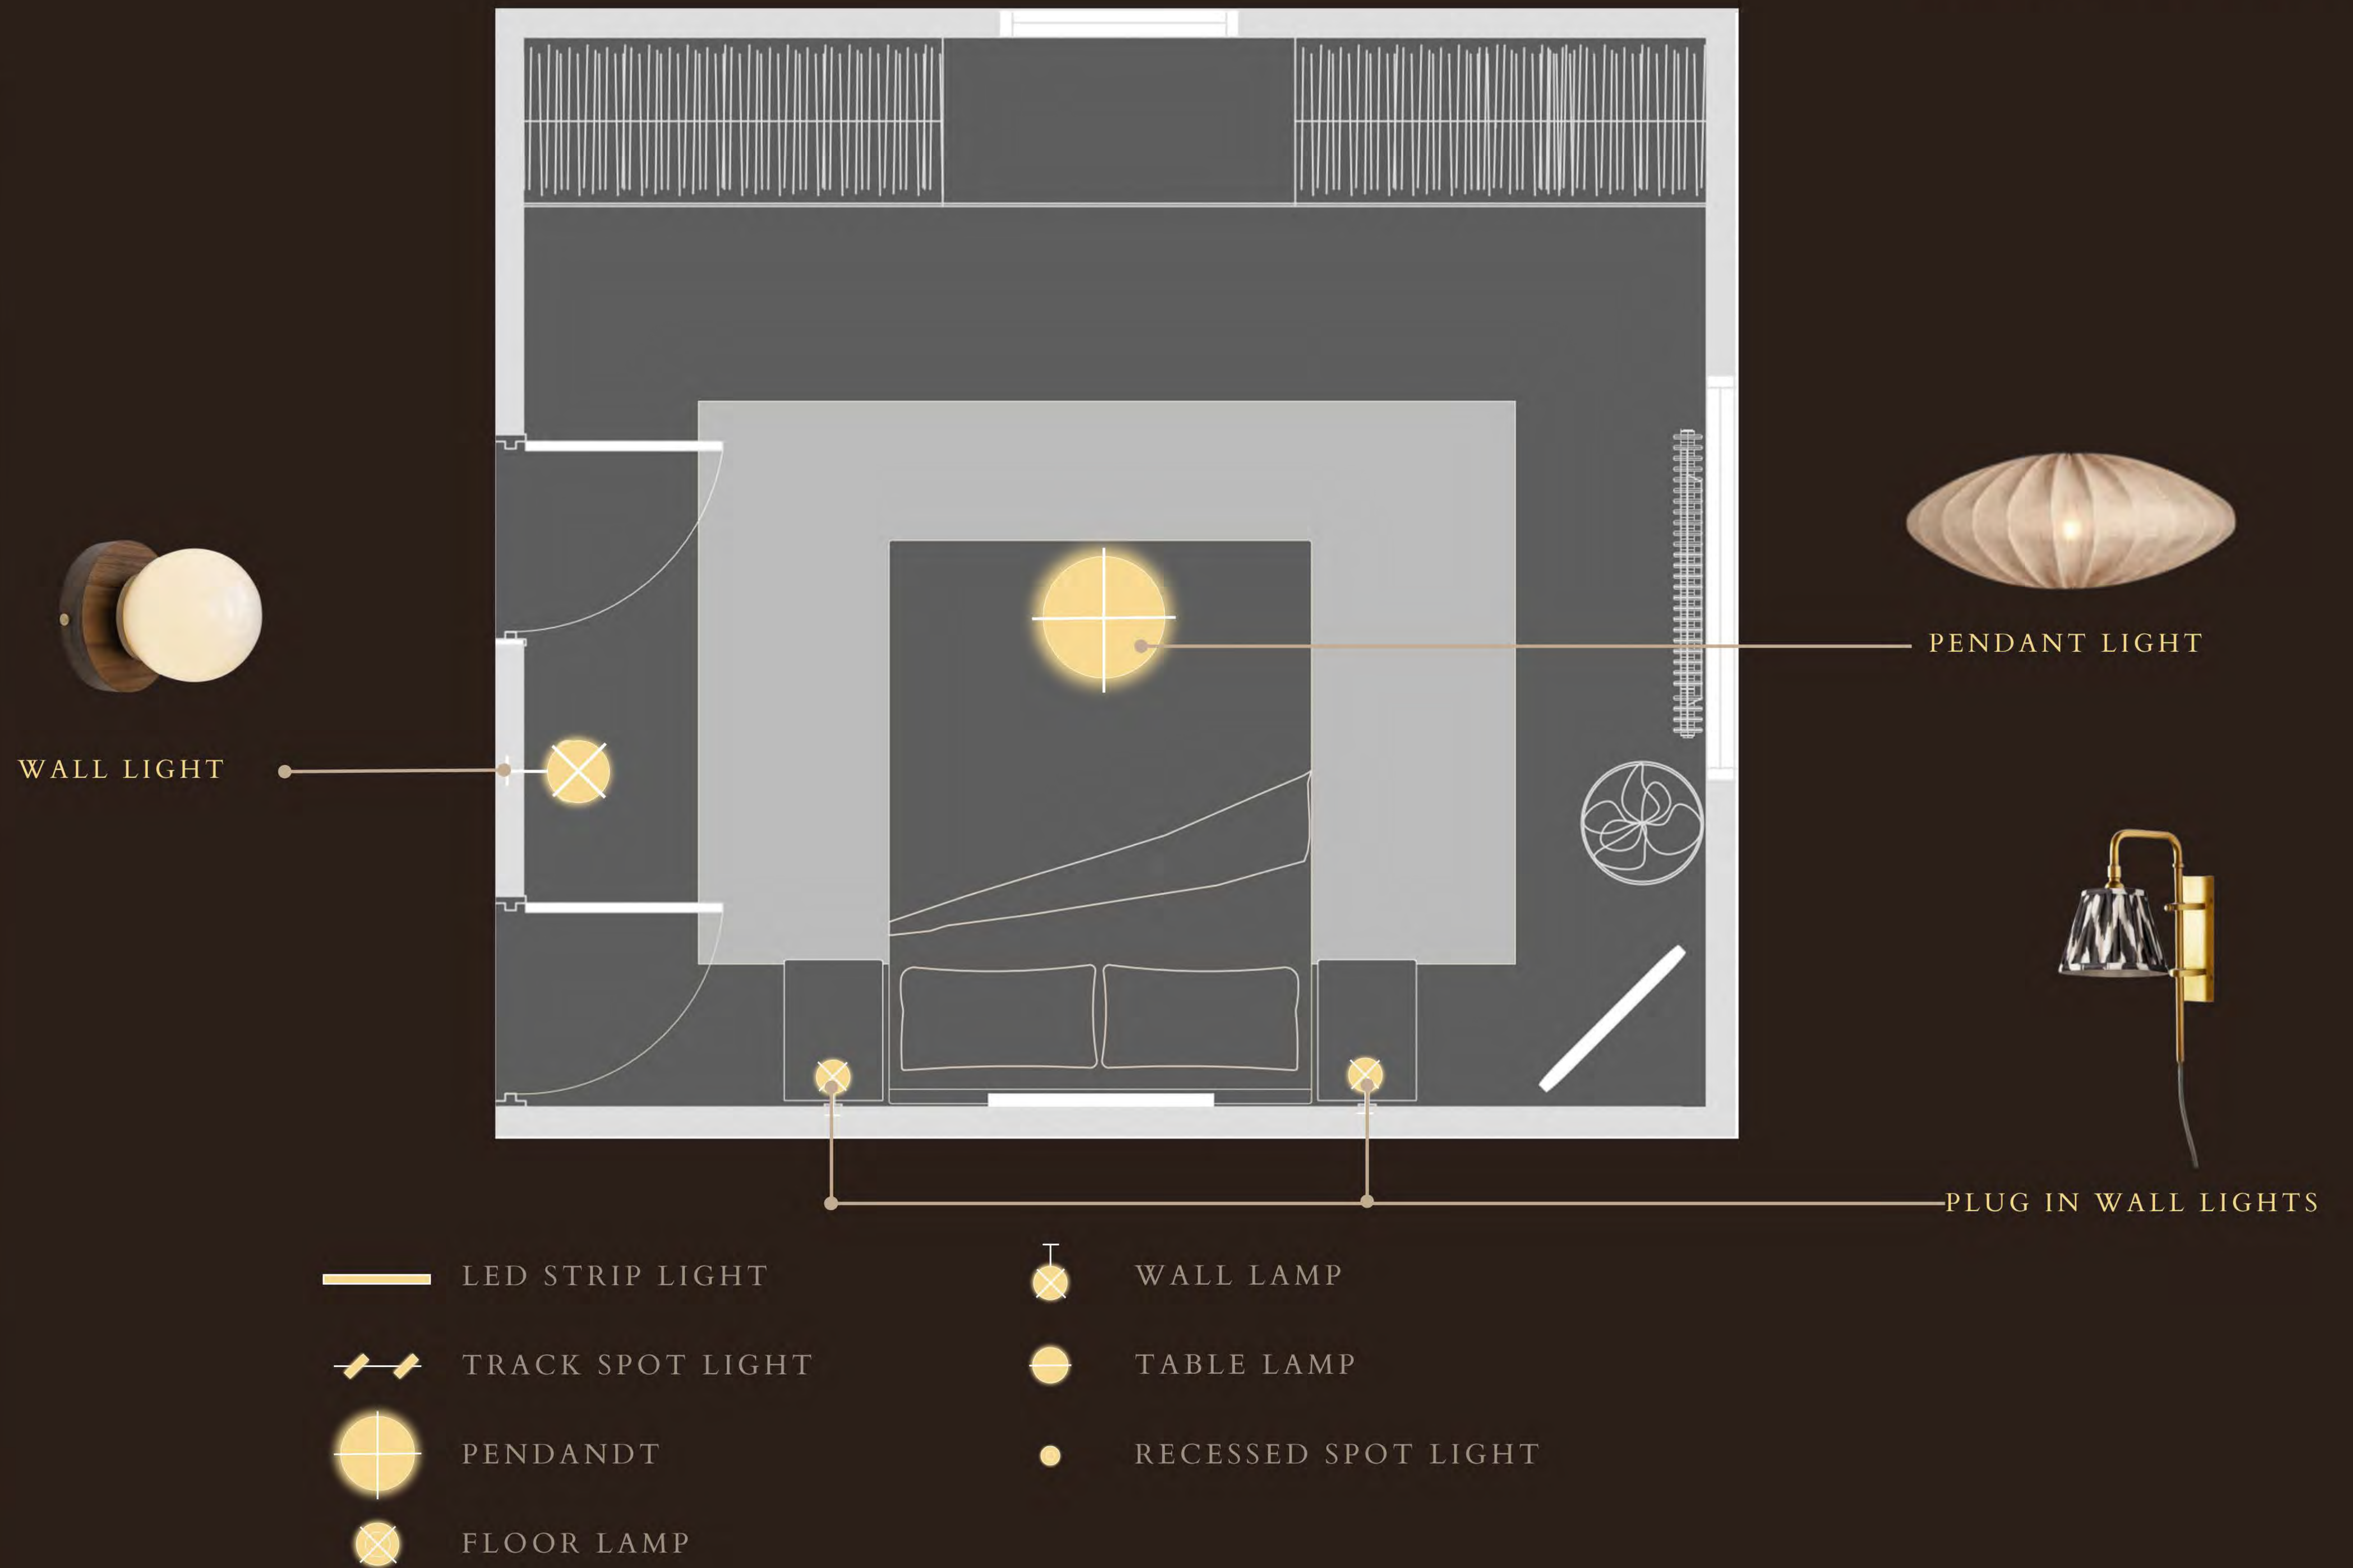

Before



After

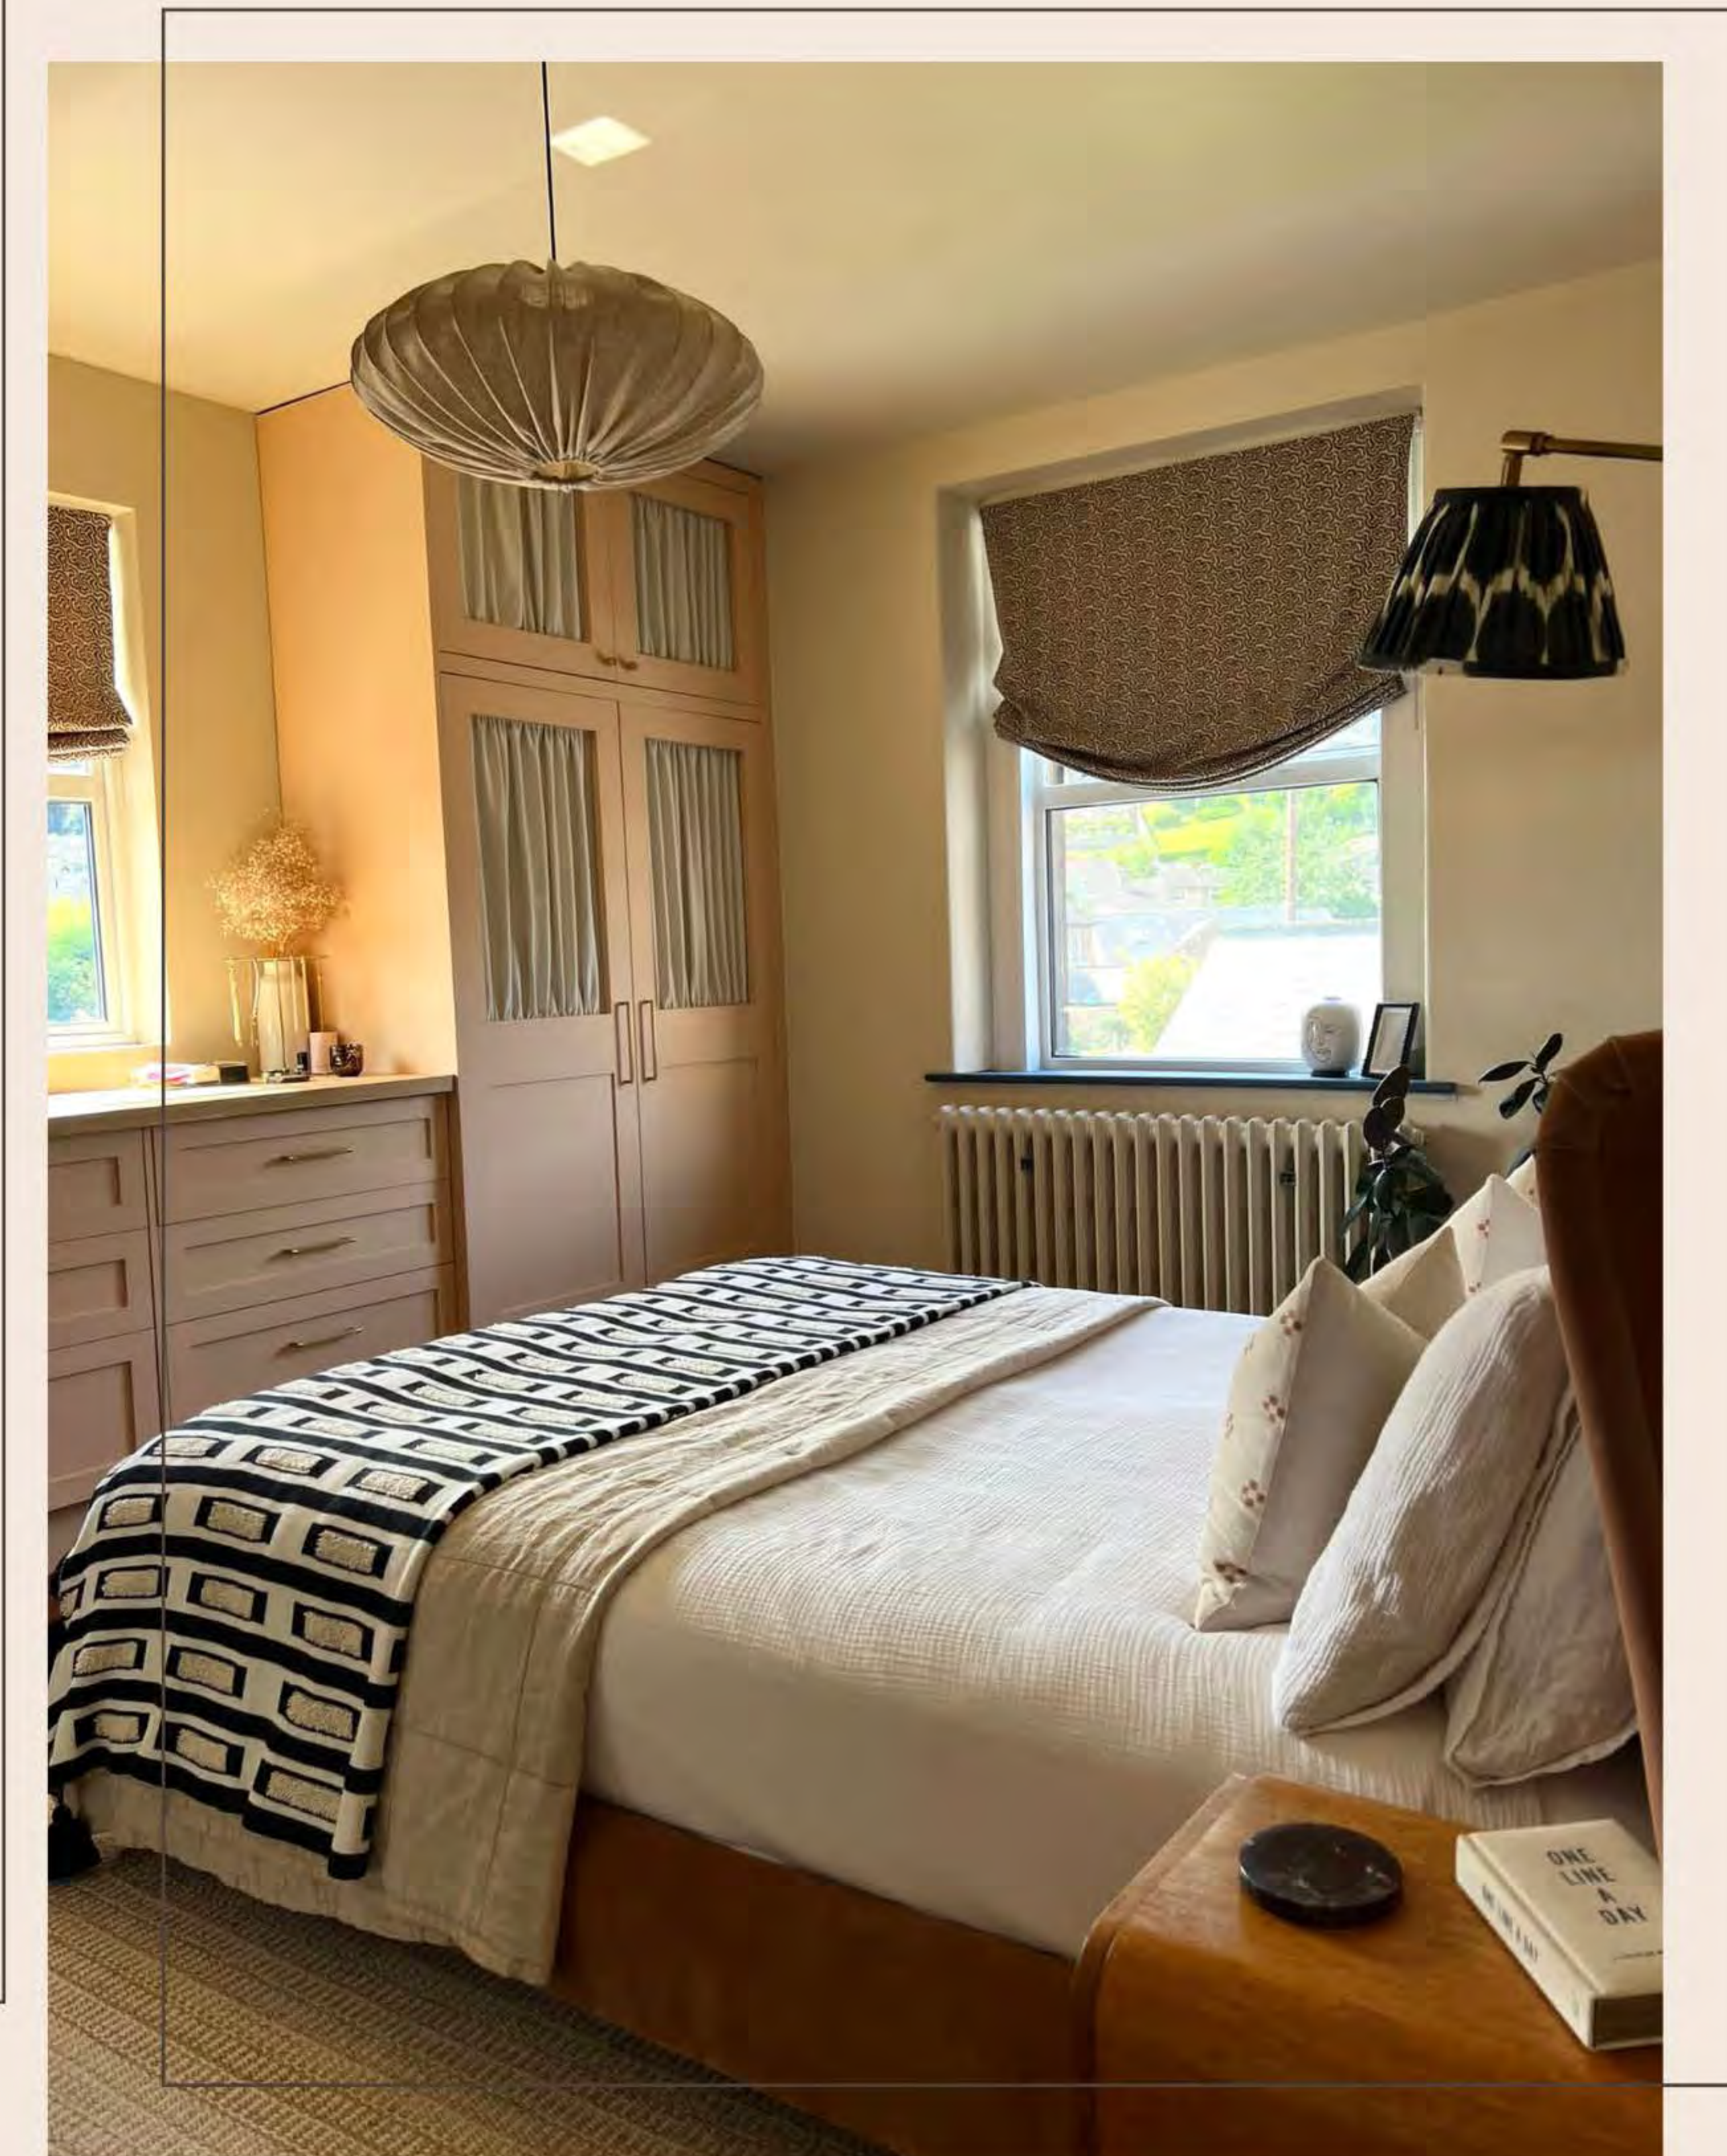

RESULTS

Thank You